

CONSTRUCTION PLANS

FOR

KEWADIN WATERFRONT PARK AND WATER TRAIL HEAD

- SITE IMPROVEMENTS & BUILDING DEVELOPMENT -

MNRTF Grant #TF17-0006

MILTON TOWNSHIP, ANTRIM COUNTY, MICHIGAN



VICINITY MAP
SCALE

OWNER

MILTON TOWNSHIP,
ANTRIM COUNTY
7023 CHERRY AVE.
KEWADIN, MICHIGAN, 49648
CONTACT: LON BARGY, TOWNSHIP SUPERVISOR
231-264-6612
PROJECT ADDRESS: 7263 CAIRN HWY.
KEWADIN, MICHIGAN, 49648


LANDSCAPE ARCHITECT / ENGINEER

GOSLING CZUBAK ENGINEERING SCIENCES, INC.
1280 BUSINESS PARK DRIVE
TRAVERSE CITY, MICHIGAN, 49686-8607
231.946.9191 - 800.968.1062
www.goslingczubak.com info@goslingczubak.com



ARCHITECT

JLM DESIGN GROUP LTD.
225 E. 16TH ST. SUITE B
TRAVERSE CITY, MICHIGAN, 49686
PHONE: 231.947.9019
EMAIL: jlm@gatt.net

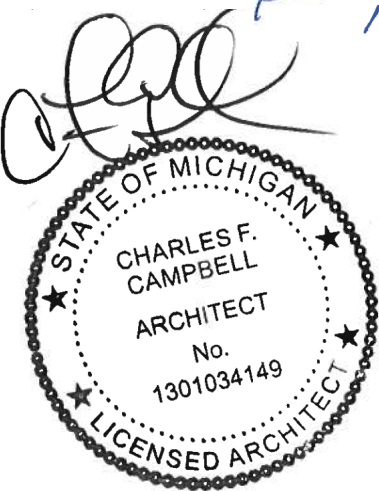


UTILITY CONTACTS

NAME OF OWNER	TYPE OF UTILITY
DTE ENERGY 609 BJORNSON RD. BIG RAPIDS, MI 49307 231.592.3244 CONTACT: LARRY BOURKE	GAS
CONSUMER'S ENERGY 821 HASTINGS TRAVERSE CITY, MI 49686 231.929.6265 CONTACT: CURTIS HANSEN	ELECTRIC
CHARTER COMMUNICATIONS 1392 TRADE CENTRE DR TRAVERSE CITY, MI 49696 231.941.3819 CONTACT: DAN BIELACZYK	CABLE TV
AT&T 142 E. STATE STREET TRAVERSE CITY, MI 49684 248.454.2995 CONTACT: TAMERA HARDIN	TELEPHONE
MILTON TOWNSHIP 7023 CHERRY AVE. KEWADIN, MI 49648 231.264.6612	SEWER & WATER



Know what's below.
Call before you dig.

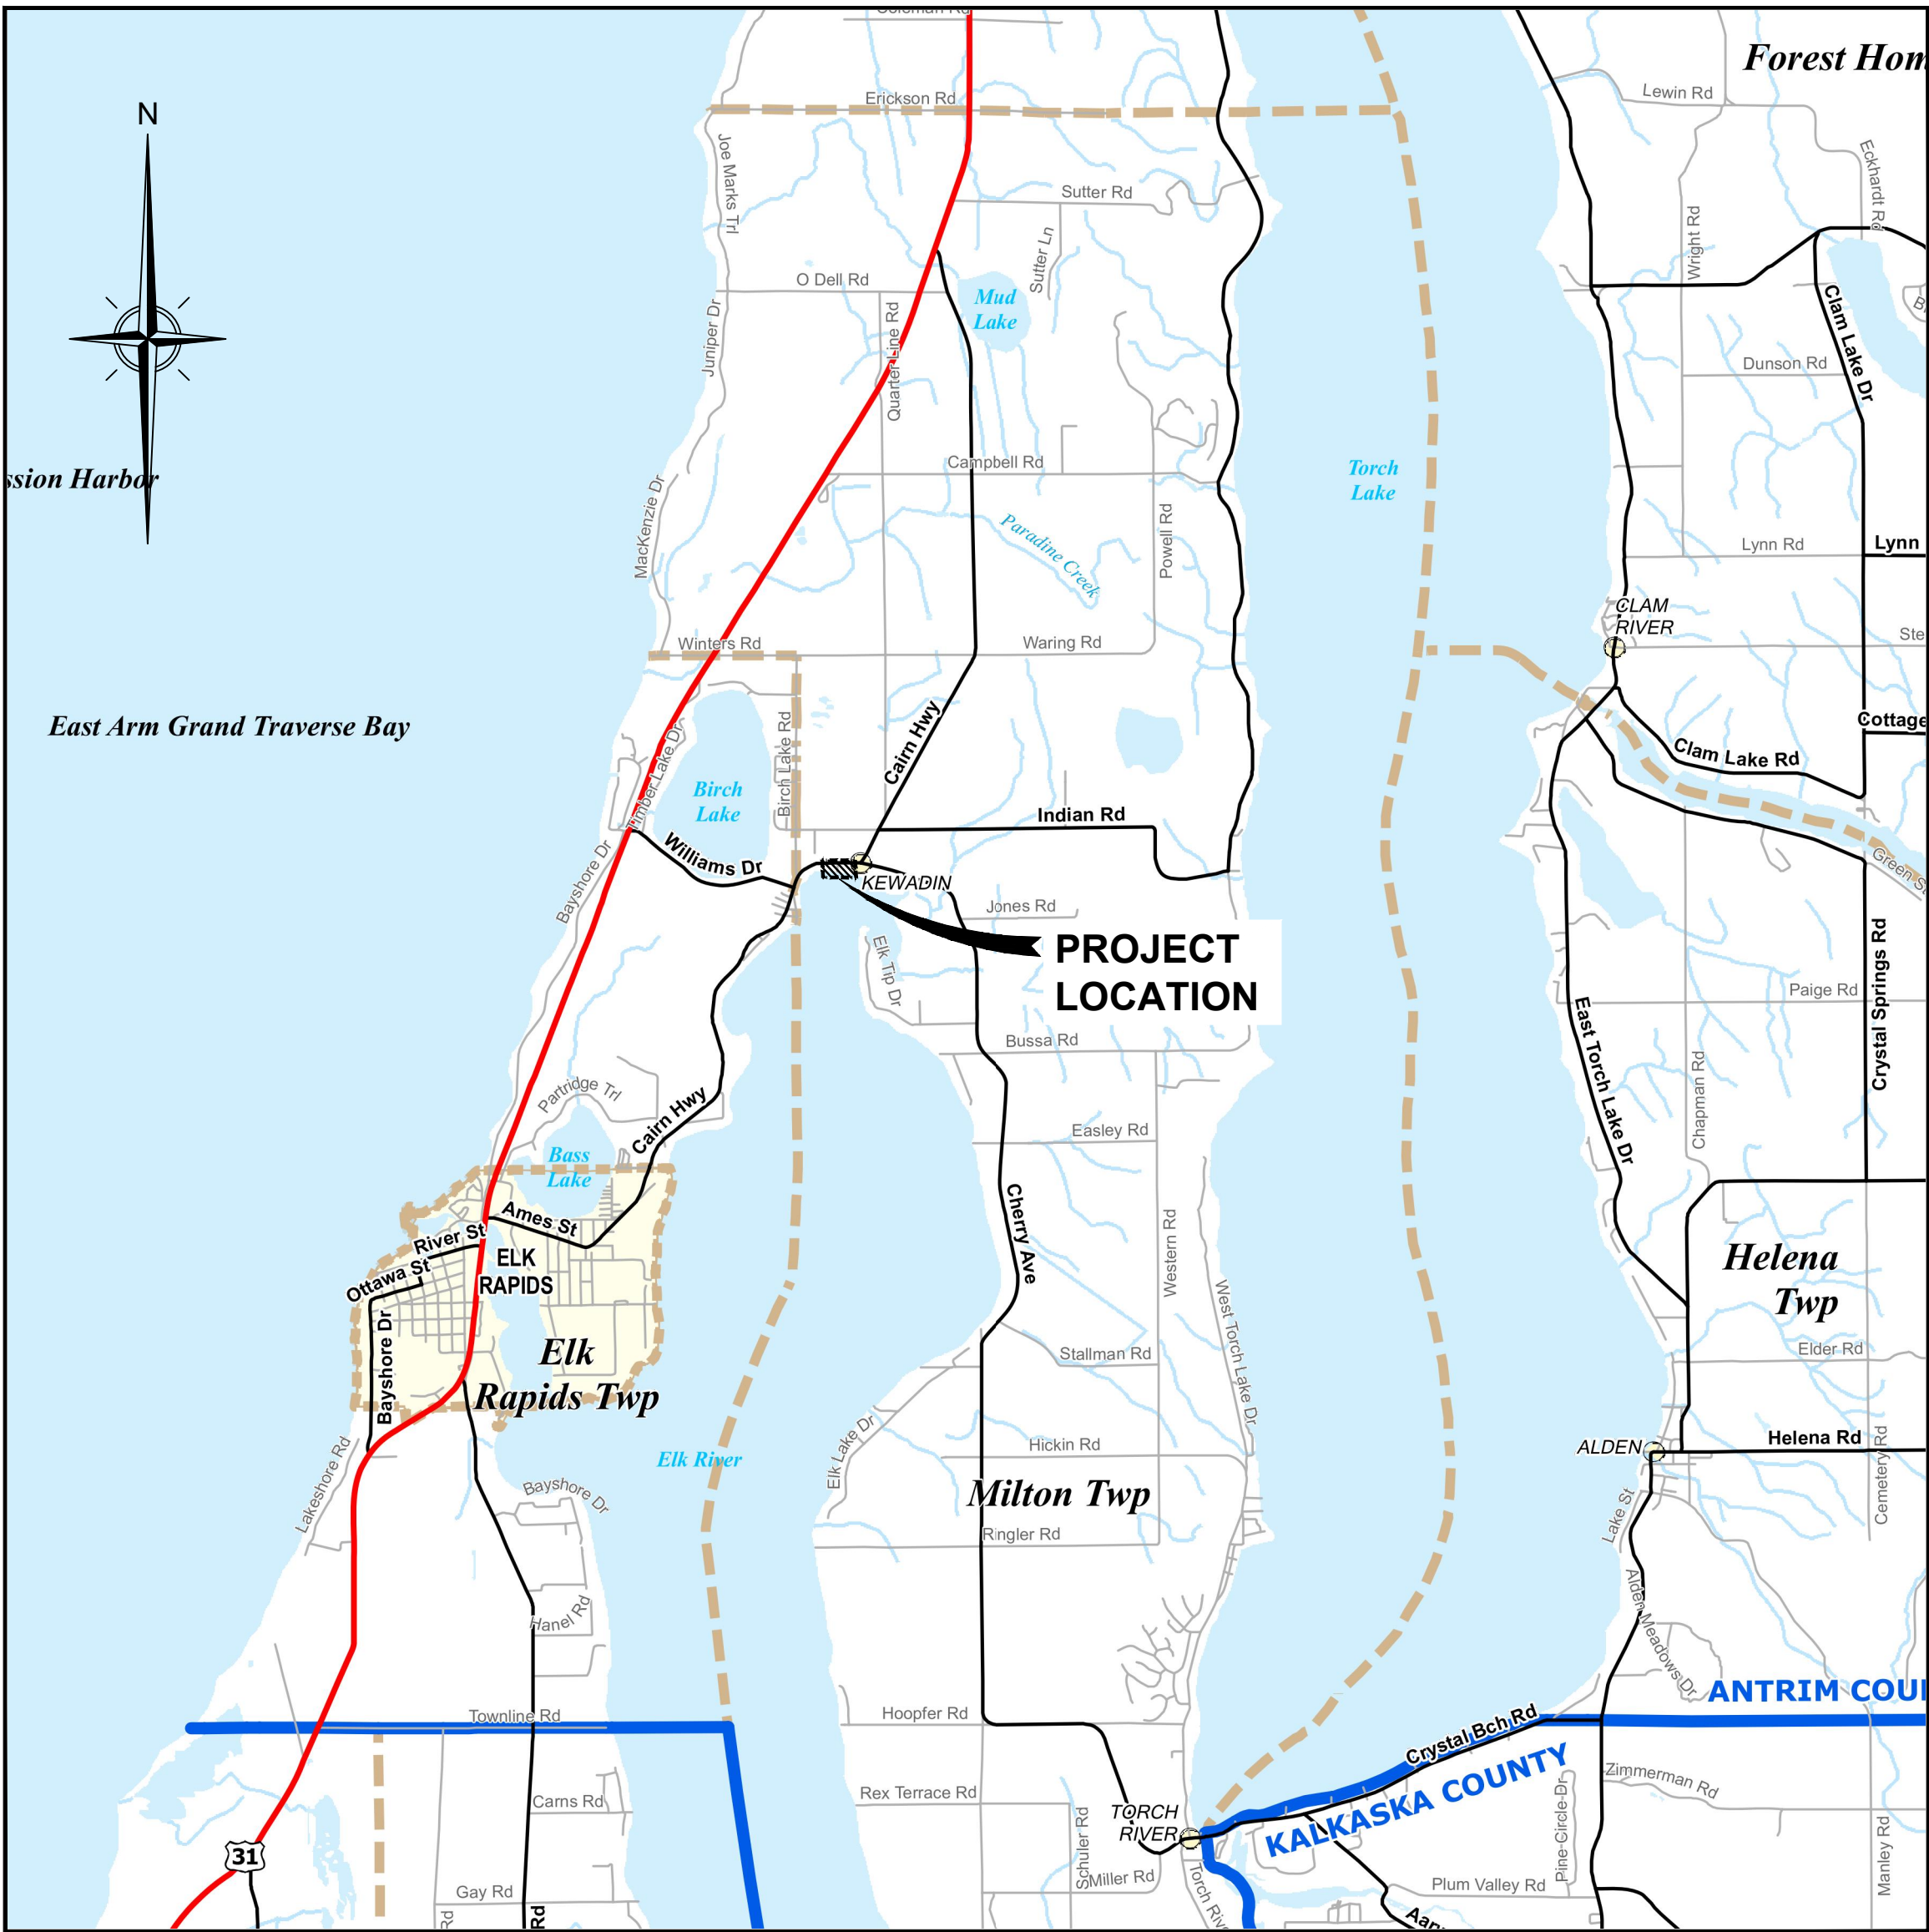

LOCATION MAP
NOT TO SCALE

SHEET INDEX

- C1 COVER SHEET
- G1 GENERAL NOTES
- S1 EXISTING CONDITIONS AND REMOVALS
- S2 OVERALL SITE PLAN
- S3 LAYOUT AND GRADING PLAN
- D1 WALL ELEVATION CONSTRUCTION DETAILS
- D2 CONSTRUCTION DETAILS
- L1 LANDSCAPE PLAN AND DETAILS
- L2 SIGNAGE PLAN
- A1 DEMOLITION PLAN
- A2 FLOOR PLAN
- A3 EXTERIOR ELEVATIONS
- A4 EXTERIOR ELEVATIONS
- A5 BUILDING SECTIONS
- A6 TOILET DETAILS
- ST1 FRAMING PLAN
- ST2 ROOF FRAMING PLAN
- MP1 MECHANICAL PLAN
- E1 ELECTRICAL PLAN

BUILDING PLAN

BUILDING CODE REQUIREMENTS: CONFORMS TO 2015 MICHIGAN
BUILDING CODE USE GROUP:

FIRST FLOOR: ASSEMBLY (A-3)

BASEMENT: UTILITY (U)

CONSTRUCTION CLASSIFICATION: 5B

BUILDING ALLOWED: 5500 S.F.; 1 STORY; 40 FT. HEIGHT

BUILDING SEPARATED BY 2 HOUR FLOOR/ CEILING FIRE SEPARATION
ASSEMBLY

BUILDING CONTAINS: 2121 S.F. (PER FLOOR); 2 STORY; 30 FT. HEIGHT

FIRE RESISTANCE RATING REQUIREMENTS

PRIMARY STRUCTURE FRAME (BASEMENT) - 2 HOUR

PRIMARY STRUCTURE FRAME (FIRST FLOOR) - 0 HOUR

BEARING WALLS

- EXTERIOR (BASEMENT) - 2 HOUR
- INTERIOR (BASEMENT) - 0 HOUR
- EXTERIOR (FIRST FLOOR) - 0 HOUR
- INTERIOR (FIRST FLOOR) - 0 HOUR

NON-BEARING INTERIOR WALLS AND PARTITIONS - 0 HOUR

FLOOR CONSTRUCTION - 2 HOUR

ROOF CONSTRUCTION - 0 HOUR

KEWADIN WATERFRONT PARK AND WATER TRAIL HEAD

Issue Date 02-12-19
Project No. 2018528001.00
Sheet C1

1. REMOVE ALL TREES AS INDICATED ON PLANS. INCLUDING CUTTING STUMP AND GRINDING 12" MIN BELOW FINISHED GRADE AS INDICATED ON PLANS.
2. PROTECT ALL TREES AND SHRUBS NOT SCHEDULED FOR REMOVAL AS INDICATED ON PLANS. DO NOT OPERATE EQUIPMENT, STORE, STOCKPILE, OR PARK WITHIN DRIFLINE (DIAMETER OF CANOPY) OF TREES TO MINIMIZE SOIL COMPACTION AND PROTECT ROOT ZONE OF TREE. PROVIDE SILT FENCE BARRIER AROUND DRIP LINE OF TREE WHERE INDICATED ON PLANS. HOLD NECESSARY DISTURBANCE TO A MINIMUM.
3. CONTRACTOR TO PROVIDE FINAL LOCATION OF STOCKPILE, MATERIAL AND MACHINERY STAGING AREAS AND GET APPROVAL FROM LANDSCAPE ARCHITECT AND OWNER PRIOR TO COMMENCING WORK ON-SITE. CONTRACTOR WILL ENSURE ADEQUATE EROSION CONTROL MEASURES NOT LIMITED TO SILT FENCE INSTALLATION.
4. DO NOT OPERATE HEAVY MACHINERY BELOW SHORELINE UNLESS APPROVED BY THE PROFESSIONAL
5. THE CONTRACTOR WILL BE HELD RESPONSIBLE FOR DAMAGE TO ITEMS NOT SCHEDULED FOR REMOVAL.
6. TOP SOIL AND RESEED ALL AREAS DISTURBED BY CONSTRUCTION ACTIVITIES. REFER TO PLANS FOR SITE RESTORATION REQUIREMENTS.
7. REMOVAL ITEMS SHOWN ARE BASED ON BEST AVAILABLE INFORMATION AND ARE SHOWN SCHEMATICALLY. THE CONTRACTOR SHALL WALK THE SITE PRIOR TO BID TO BECOME FAMILIAR WITH THE EXTENT OF REMOVAL ITEMS. THE CONTRACTOR IS RESPONSIBLE FOR ALL REMOVALS NECESSARY TO COMPLETE CONSTRUCTION. QUESTIONS REGARDING ITEMS TO BE REMOVED SHALL BE DIRECTED TO THE LANDSCAPE ARCHITECT.
8. PRIOR TO CONSTRUCTION, REMOVE AND SALVAGE ALL ITEMS AS INDICATED ON PLANS.
9. STRIP AND STOCKPILE TOPSOIL IN A LOCATION APPROVED BY THE ENGINEER AND PROVIDE ALL NECESSARY S.E.S.C. MEASURES TO ELIMINATE EROSION. DO NOT STRIP TOPSOIL FROM AREAS TO BE RESTORED WITH NATIVE SEED EXCEPT IF DISTURBED BY EARTHWORK OR FOR NEW RETENTION AREAS AS INDICATED ON THE PLANS.
10. COORDINATE ELECTRICAL SERVICE, DISTRIBUTION, REMOVALS WITH LOCAL UTILITY COMPANY.

1. ALL SIGNS AND SIGN PLACEMENT, WHERE APPLICABLE, WILL BE IN COMPLIANCE WITH THE MICHIGAN MANUAL OF UNIFIED TRAFFIC CONTROL DEVICES.
2. THE CONTRACTOR WILL SUPPLY THE NECESSARY SIGNS, SIGNALS, LIGHTING DEVICES, MARKINGS, BARRICADES, CHANNELLING, AND HAND SIGNAL DEVICES TO PROPERLY SIGN THE JOB PERMITTED. THE CONTRACTOR WILL PROVIDE DESIGN, APPLICATION, INSTALLATION, AND MAINTENANCE OF VARIOUS TRAFFIC CONTROL DEVICES REQUIRED FOR ROAD OR STREET CONSTRUCTION. TRAFFIC CONTROL PLAN SHALL BE SUBMITTED PRIOR TO COMMENCEMENT OF CONSTRUCTION FOR APPROVAL BY THE ENGINEER AND ECRG.
3. CONSTRUCTION STAKING SHALL BE THE RESPONSIBILITY OF THE CONTRACTOR. (SEE SPECIFICATION SECTION 01050)
4. DIMENSIONS ARE TO EDGE OF CONCRETE, ASPHALT, OR GRAVEL.
5. SITE CONTRACTOR SHALL COORDINATE INSTALLATION OF ALL SLEEVES NECESSARY FOR IRRIGATION AND SITE ELECTRICAL DISTRIBUTION - SLEEVES LOCATIONS ON THE PLANS ARE APPROXIMATE AND ARE THE MINIMUM REQUIRED.


1. CONSTRUCTION STAKING SHALL BE THE RESPONSIBILITY OF THE CONTRACTOR.
2. ELEVATIONS SHOWN ARE BASED ON NAVD 88
3. INSTALL MULCH BLANKET ON ALL SLOPE GREATER THAN 4:1
4. SITE CONTRACTOR SHALL COORDINATE INSTALLATION OF ALL SLEEVES NECESSARY FOR IRRIGATION AND SITE ELECTRICAL DISTRIBUTION.
5. SITEWORK CONTRACTOR IS RESPONSIBLE FOR ROUGH GRADING OF SITE, TOPSOIL PLACEMENT, FINAL GRADING, SEEDING, HYDROSEEDING AND PLACEMENT OF MULCH BLANKET ON SLOPES GREATER THAN 4:1 TO MEET S.E.C GUIDELINES AND PERMIT DIRECTIVES.


MINIMUM COVER ON ALL BURIED WATER LINES, 3'-0". UNLESS OTHERWISE NOTED.


1. REUSE EXISTING WELL IN ACCORDANCE WITH ALL LOCAL, STATE AND AGENCY REQUIREMENTS.
2. SITE ELECTRICAL DIAGRAMS, LAYOUTS, COMPONENT SIZING AND MATERIALS INTENDED TO GUIDE CONTRACTOR FOR PLANNING AND PRICING PURPOSES. IT IS THE CONTRACTOR'S RESPONSIBILITY TO PROVIDE ALL APPLICABLE COMPONENTS AND MATERIALS NECESSARY FOR A COMPLETE AND OPERABLE SYSTEM.
3. CONTRACTOR TO COORDINATE ALL TESTING AND START-UP OF UTILITIES.
4. CONTRACTOR TO COORDINATE PUMP OUT OF EXISTING SNS HOLDING TANKS WITH TWP. VENDOR GMOSEY'S SEPTIC TANK PUMP (231) 264-8838, PRIOR TO DEMO IN PLACE.

 
1. ALL ELECTRICAL LINES UNDER VEHICULAR PAVEMENT SHALL BE ENCASED IN 4" SCHED. 40 SLEEVE, MIN. 36" BELOW FINAL GRADE AND EXTEND MIN. 3' BEYOND PAVEMENT EDGE.
2. LOCATE PROGRAMMABLE TIMER AND DIMMING CAPABILITIES IN RESTROOM FOR SITE LIGHTING.
3. ALL ELECTRICAL SHALL MEET UNIVERSAL AND LOCAL CODE. SHOP DRAWINGS OF ELECTRICAL LAYOUT AND ASSEMBLY TYPE AND LOCATION SHALL BE PROVIDED AND APPROVED BY THE ENGINEER PRIOR TO PURCHASING AND INSTALLING ANY SYSTEM COMPONENTS.
4. SITE CONTRACTOR SHALL COORDINATE INSTALLATION OF ALL SLEEVES NECESSARY FOR IRRIGATION AND SITE ELECTRICAL DISTRIBUTION - SLEEVES LOCATIONS ON THE PLANS ARE APPROXIMATE AND ARE THE MINIMUM REQUIRED.


1. SITE CONTRACTOR TO MONITOR AND ENSURE PROPER WORKING OF ALL INSTALLED SESC MEASURES THROUGHOUT CONSTRUCTION.
2. CONTRACTOR RESPONSIBLE FOR FINAL RESTORATION SEEDING AND MULCHING PRIOR TO FINAL COMPLETION OF THE WORK.
3. CONTRACTOR RESPONSIBLE TO MAINTAIN ALL SESC MEASURES REMAINING AFTER FINAL COMPLETION UNTIL ESTABLISHMENT AND FINAL ACCEPTANCE BY THE PROFESSIONAL.
4. MILTON TOWNSHIP TO MONITOR ALL SESC MEASURES UNTIL ESTABLISHMENT AND REPORT ANY FAILURES TO BE RECTIFIED.
5. MILTON TOWNSHIP TO MAINTAIN ALL AREAS AFTER FINAL ESTABLISHMENT AND CONTINUE AS REGULAR MAINTENANCE.

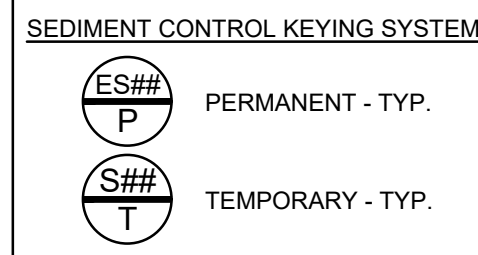


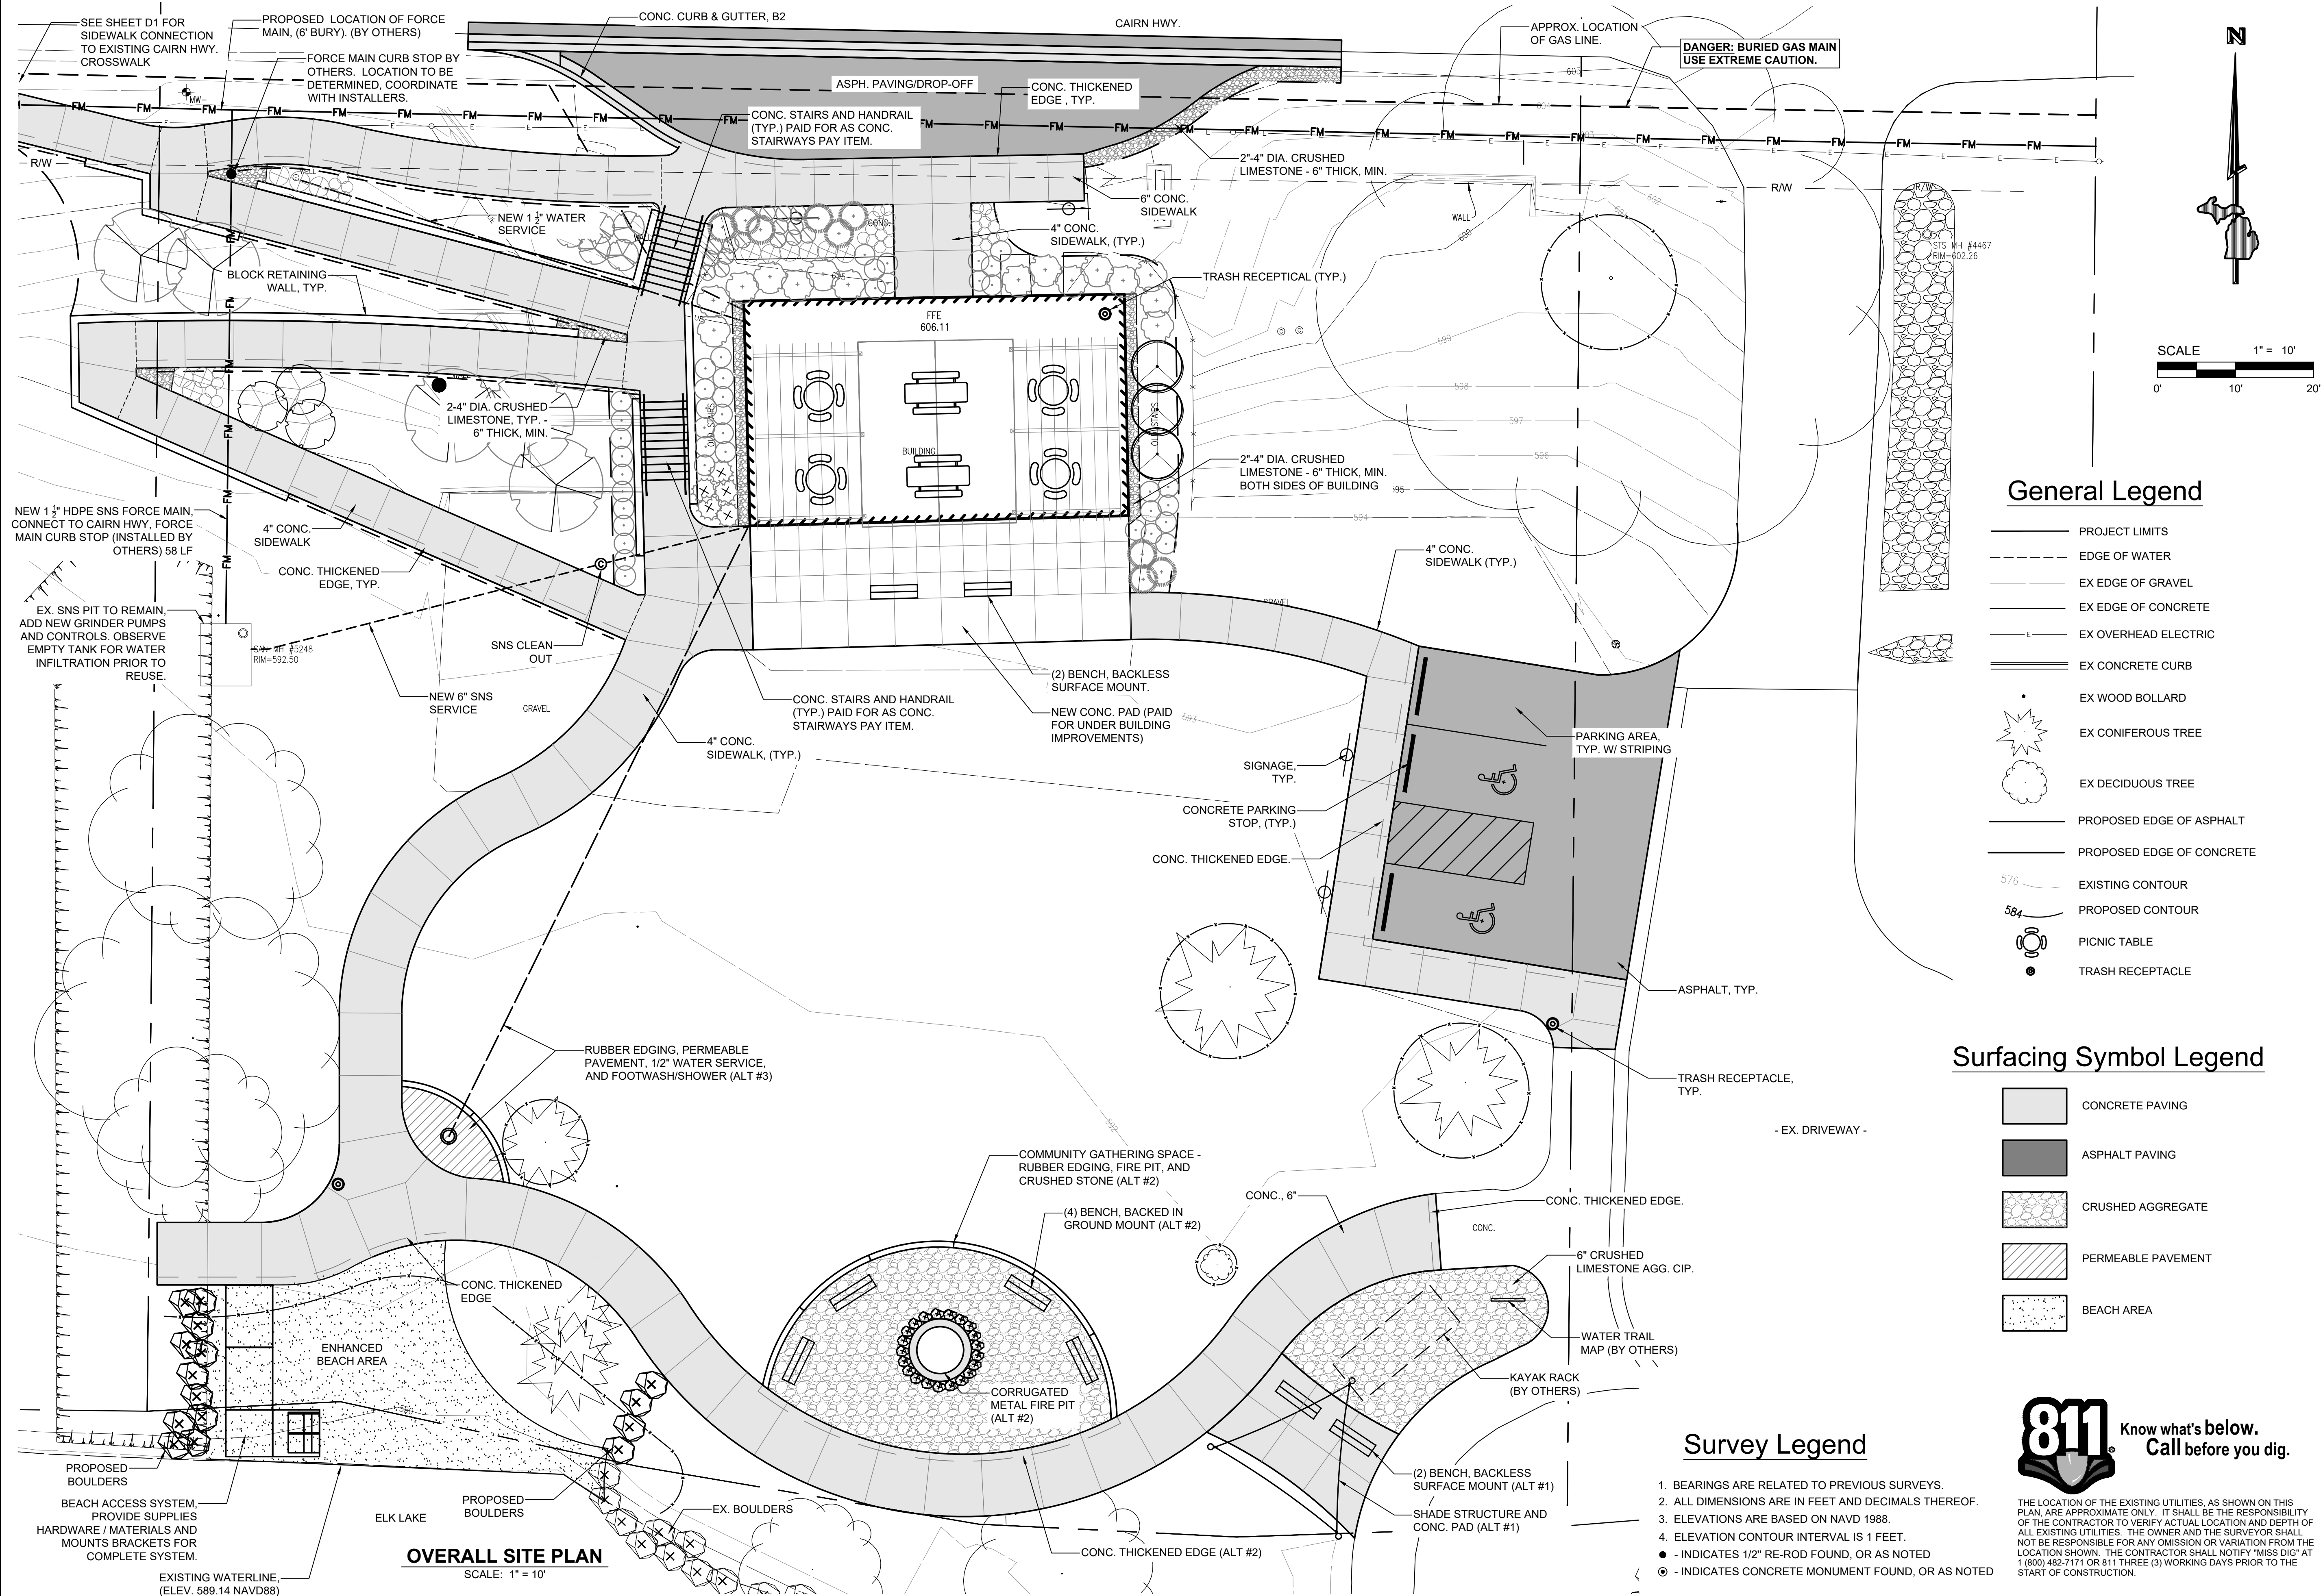

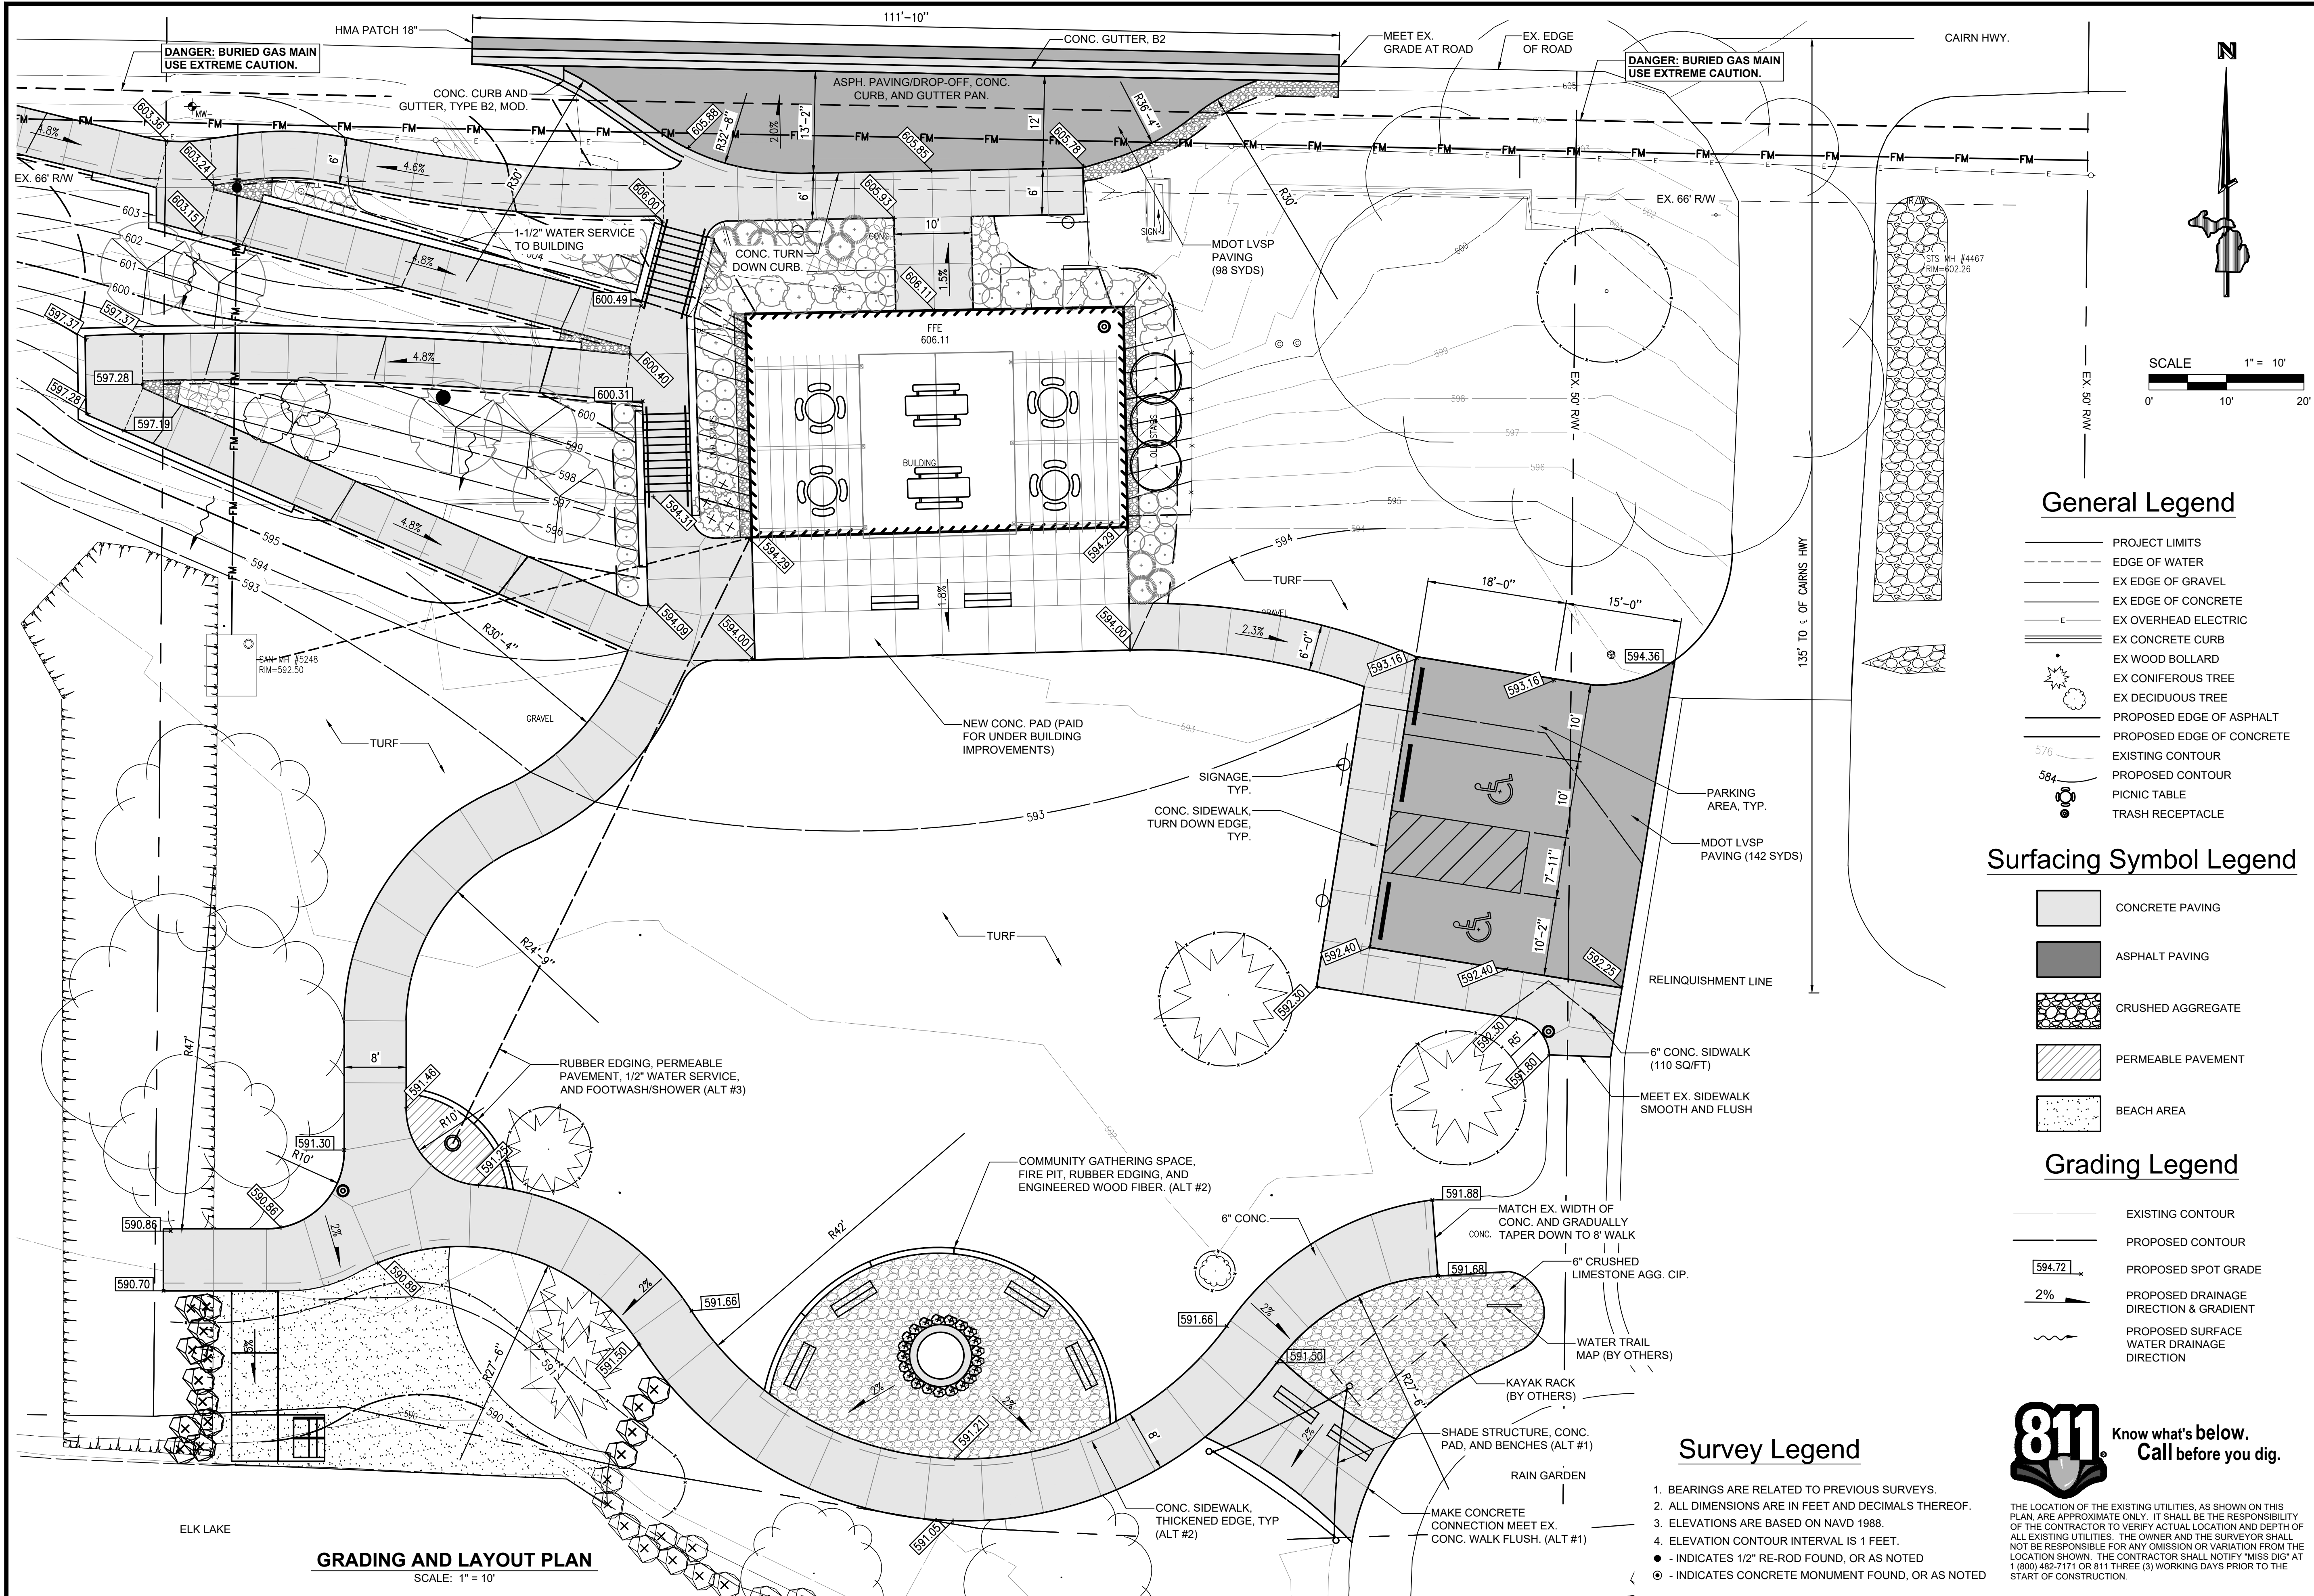



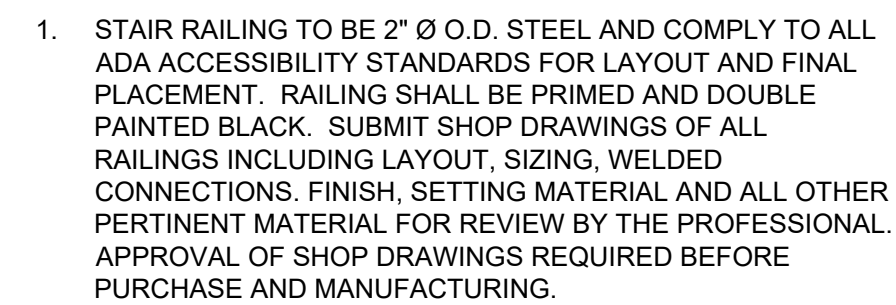

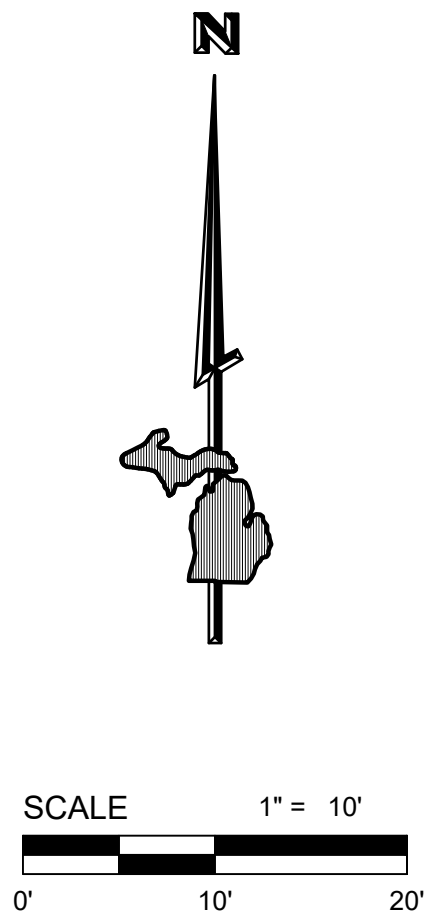

- | | |
|---|---------------------------|
|  | PROJECT LIMITS |
|  | EDGE OF WATER |
|  | EX EDGE OF GRAVEL |
|  | EX EDGE OF CONCRETE |
|  | EX OVERHEAD ELECTRIC |
|  | EX CONCRETE CURB |
|  | EX WOOD BOLLARD |
|  | EX CONIFEROUS TREE |
|  | EX DECIDUOUS TREE |
|  | PROPOSED EDGE OF ASPHALT |
|  | PROPOSED EDGE OF CONCRETE |
|  | EXISTING CONTOUR |
|  | PROPOSED CONTOUR |





- | | |
|---|-----------------------------------|
|  | CONCRETE PAVING |
|  | ASPHALT PAVING |
|  | LOW-PROFILE PRAIRIE GRASS |
|  | ALUMINUM LANDSCAPE EDGING |
|  | PLASTIC LANDSCAPE/SIDEWALK EDGING |

1. CONTRACTOR SHALL ADEQUATELY DELINEATE PLANTING AREAS WITH MARKING PAINT OR OTHER APPROVED METHOD PRIOR TO INSTALLATION FOR APPROVAL BY LANDSCAPE ARCHITECT.
2. REFER TO SPECIFICATION 02950 FOR LANDSCAPING INSTALLATION INFORMATION.
3. IN CASE OF A DISCREPANCY, THE NUMBER OF TREE/SHRUB SYMBOLS SHOWN ON THE PLANS SHALL TAKE PRECEDENCE OVER QUANTITY ON NUMERICAL LABEL OR PLANT SCHEDULE.
4. PROVIDE A MINIMUM 3" DEPTH OF RED PINE LANDSCAPE MULCH (EQUAL TO RED PINE MULCH FROM TRAVERSE OUTDOOR, TRAVERSE CITY, MI) IN ALL PLANTING BEDS AS INDICATED ON PLANS. SUBMIT A SAMPLE OF THE MULCH TO THE LANDSCAPE ARCHITECT FOR APPROVAL PRIOR TO INSTALLATION. FINISHED GRADE OF MULCH SHALL BE FLUSH WITH GRADE OF ALL ADJACENT PAVING AND CURBS TO ALLOW FOR SETTLING.
5. PROVIDE LANDSCAPE EDGING BETWEEN MASS PLANTING AREA AND TURF/SEEDED AREAS AS INDICATED ON PLANS, OR BETWEEN AREAS RESTORED WITH DIFFERENT SEED MIXES. PROVIDE SMOOTH UNIFORM CURVES FOR EDGE AS APPLICABLE. FINAL LAYOUT TO BE APPROVED BY LANDSCAPE ARCHITECT.
6. PROVIDE EDGING EQUAL TO SURE-LOC BRAND ALUMINUM EDGING 3/16"x4" MILL FINISH WITH ANCHOR STAKES PER MANUFACTURER'S RECOMMENDATIONS. PROVIDE SAMPLE OF ALUMINUM EDGING FOR APPROVAL BY LANDSCAPE ARCHITECT.
7. THE LANDSCAPE CONTRACTOR SHALL PROVIDE PLANTING MIX FOR PLANTING MEDIUM FOR THE TREES AND SHRUBS. PROVIDE PLANTING MIX SAMPLE RATIO FOR APPROVAL BY LANDSCAPE ARCHITECT.
8. THE OWNER SHALL PROVIDE A SOURCE OF WATER ON SITE AND WILL PAY ALL WATER COSTS. LANDSCAPE CONTRACTOR WILL FURNISH ALL NECESSARY HOSE EQUIPMENT, ATTACHMENTS AND ACCESSORIES FOR ADEQUATE IRRIGATION TO COMPLETE THE WORK SPECIFIED.
9. COORDINATE THE LANDSCAPE INSTALLATION WITH IRRIGATION SYSTEM INSTALLATION. COORDINATE THE INSTALLATION WITH THE FINAL SITE PARKING AND PAVING PLAN, PROVIDE ALL NECESSARY SLEEVES UNDER PAVING AS NEEDED. COORDINATE THE LANDSCAPE INSTALLATION TO INSURE VISIBILITY OF ALL TRAFFIC SIGNAGE. COORDINATE THE LANDSCAPE INSTALLATION WITH UTILITY LOCATIONS, ESPECIALLY CATCH BASINS, LIGHT STANDARDS AND FIRE HYDRANTS.
10. STAKE THE LOCATIONS OF ALL TREES AND MASS PLANTING AREAS AND OBTAIN APPROVAL OF THE LANDSCAPE ARCHITECT PRIOR TO INSTALLATION. MAKE MINOR ADJUSTMENTS IN THE TREE LOCATIONS REQUIRED DUE TO LOCATIONS OF FIRE HYDRANTS OR OTHER UTILITY ITEMS.
11. TREES SHALL BE SELECTED WITH FORMS ADAPTABLE TO PLACEMENT ADJACENT TO SIDEWALKS AND VEHICULAR USE AREAS. TREES SHALL HAVE FORMS ADAPTABLE TO FUTURE PRUNING FOR PEDESTRIAN AND VEHICULAR CLEARANCE.
12. ALL CONTAINER GROWN MATERIAL SHALL BE THOROUGHLY HAND WATERED UPON ARRIVAL, WHILE IN THE CONTAINERS, BEFORE PLANTING. DO NOT BIND OR STRAP THE TRUNKS IN THE REMOVAL FROM THE TRUCKS. PROTECT THE TRUNKS AT ALL TIMES.
13. PROVIDE A MINIMUM 3'-0" DIAMETER TREE WELL WITH A 4" SAUCER FOR ALL TREES LOCATED IN TURF AREAS. PROVIDE 3" DEPTH OF MULCH INSIDE SAUCERS. REVIEW SUBSURFACE DRAINAGE CONDITIONS. INSTALL TREES "HIGH" IF NECESSARY, DUE TO SUBSURFACE CONDITIONS.
14. PRUNE ANY ADDITIONAL TREES AS REQUIRED BY THE LANDSCAPE ARCHITECT, GENERAL CONTRACTOR OR OWNER.
15. ALL MASS PLANTINGS SHALL BE EVENLY SPACED AS SHOWN ON PLANS TO ENSURE EVEN COVERAGE. SET PLANTS OFF CURBS AND WALKS TO PREVENT OVERGROWTH INTO UNWANTED AREAS.

SHRUB INSTALLATION DETAIL

NOT TO SCALE

THE LOCATION OF THE EXISTING UTILITIES, AS SHOWN ON THIS PLAN, ARE APPROXIMATE ONLY. IT SHALL BE THE RESPONSIBILITY OF THE CONTRACTOR TO VERIFY ACTUAL LOCATION AND DEPTH OF ALL EXISTING UTILITIES. THE OWNER AND THE SURVEYOR SHALL NOT BE RESPONSIBLE FOR ANY OMISSION OR VARIATION FROM THE LOCATION SHOWN. THE CONTRACTOR SHALL NOTIFY "MISS DIG" AT 1 (800) 482-7171 OR 811 THREE (3) WORKING DAYS PRIOR TO THE START OF CONSTRUCTION.

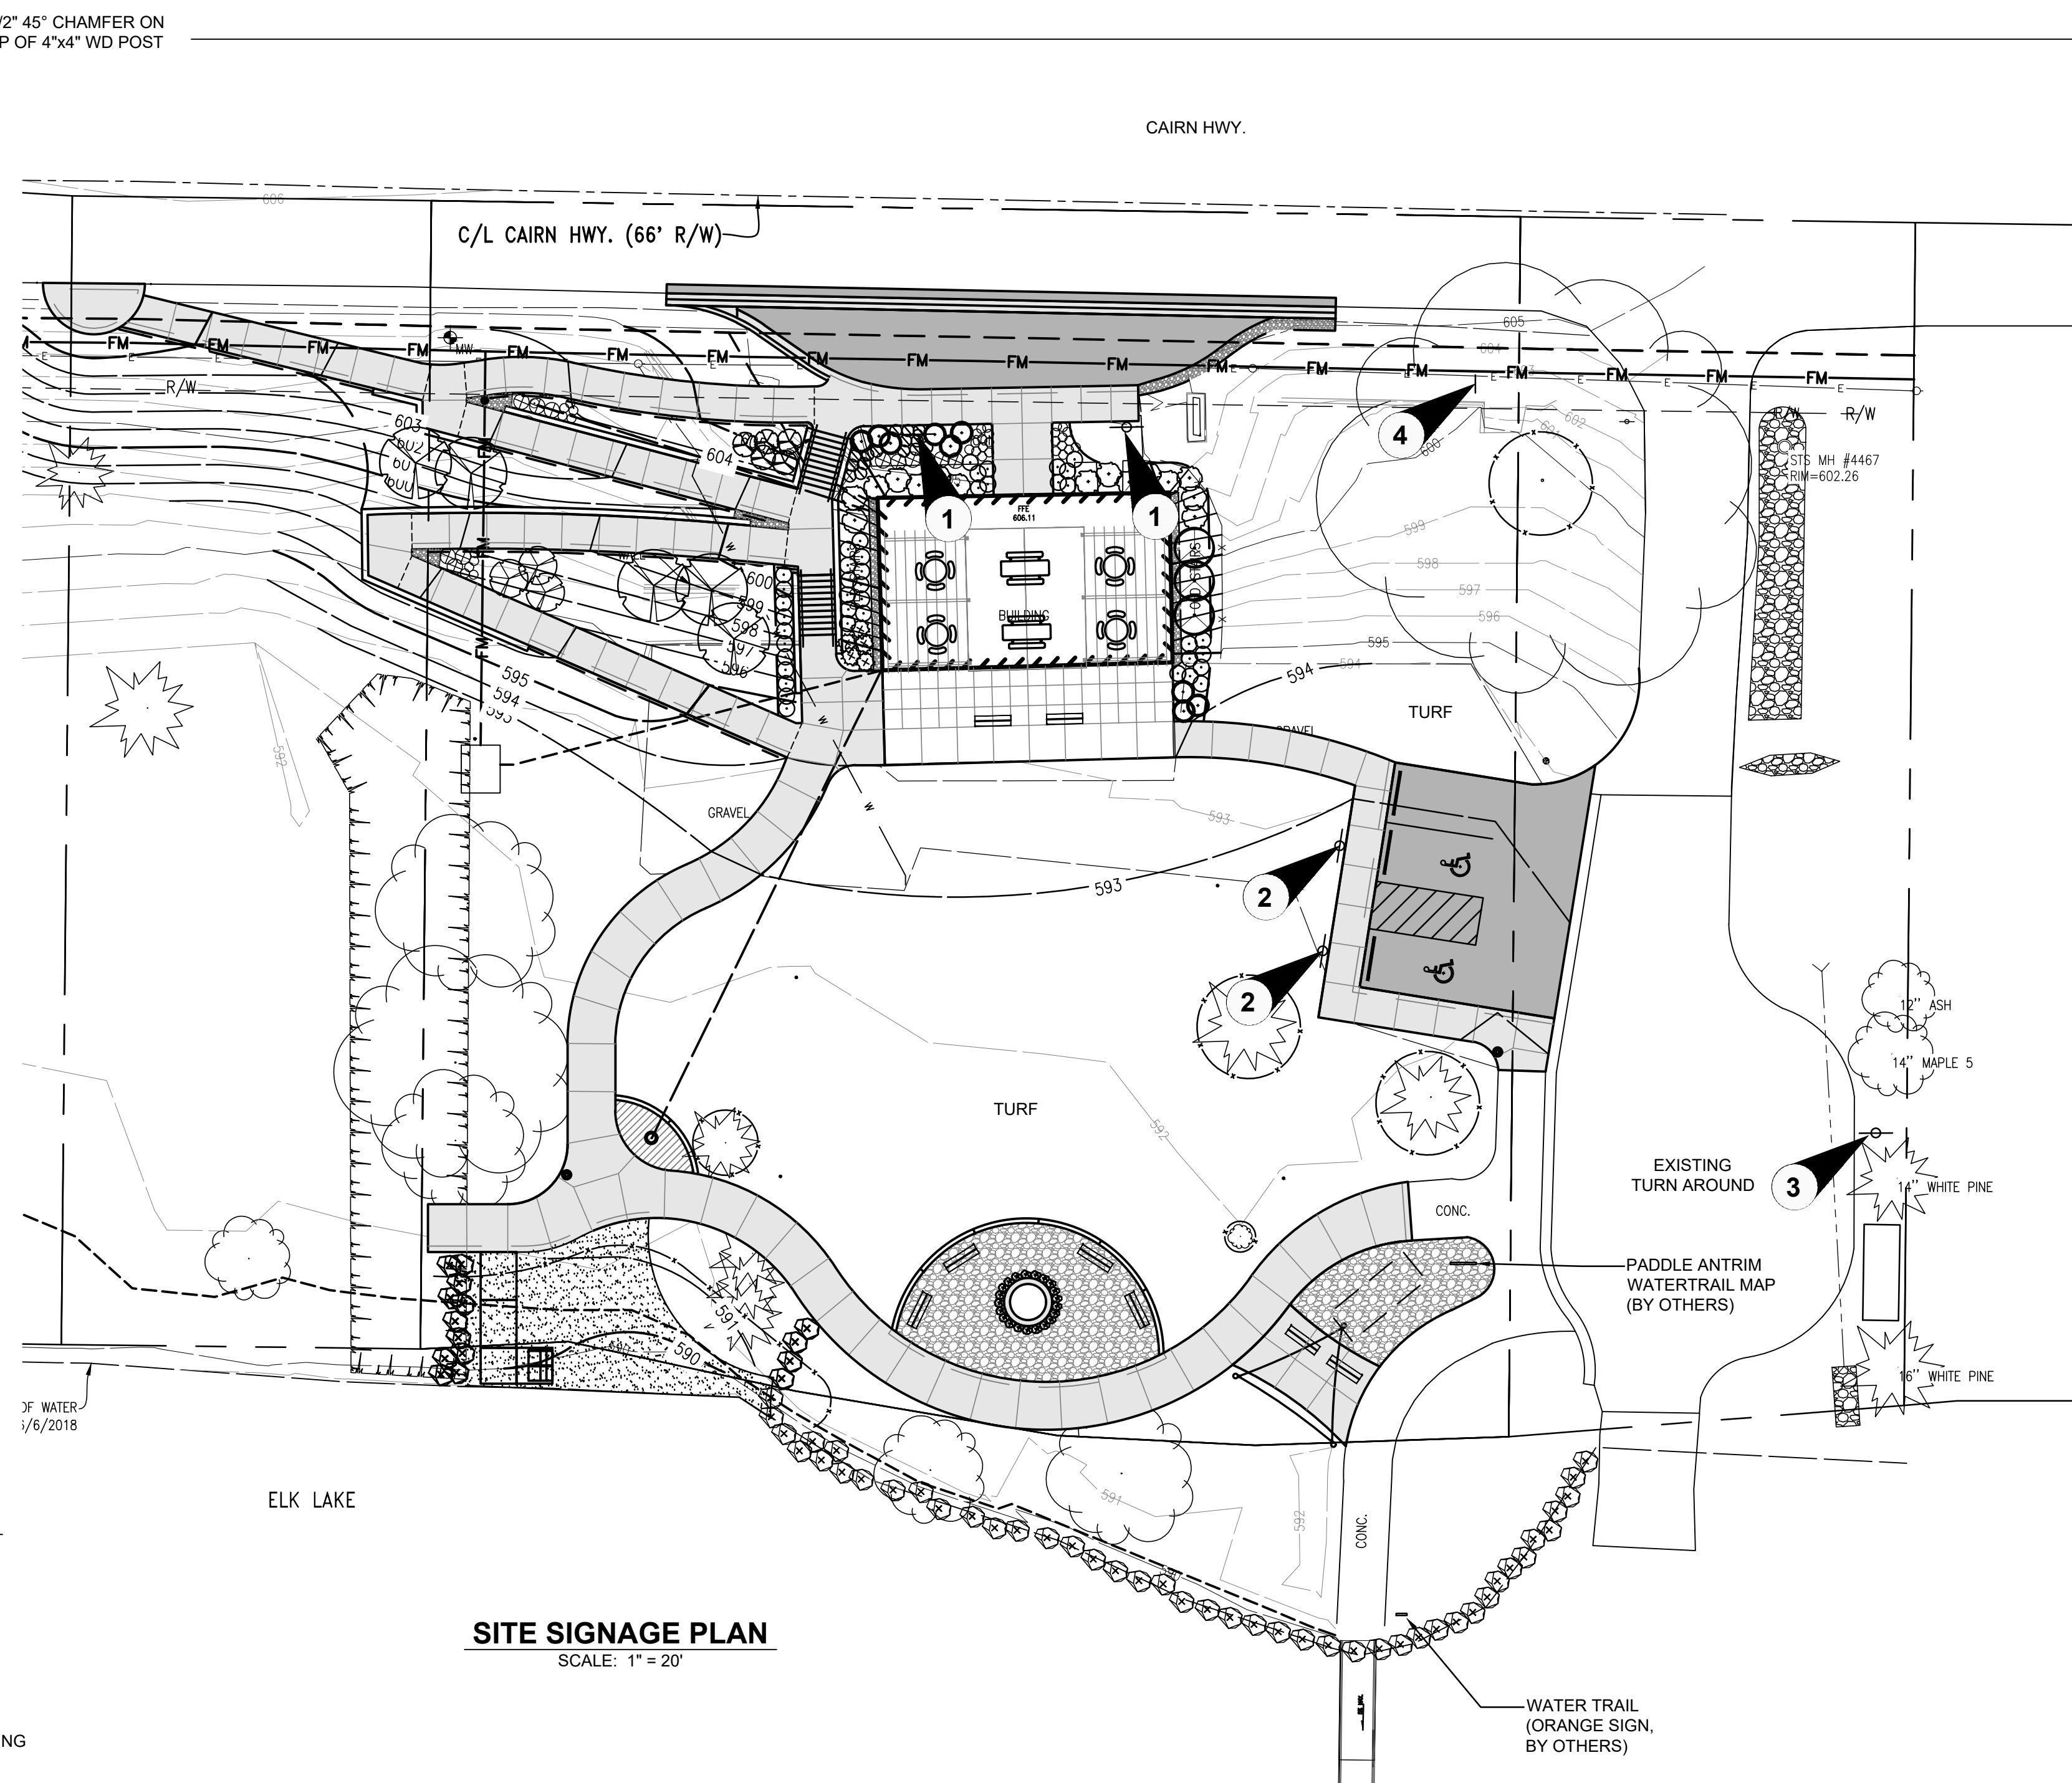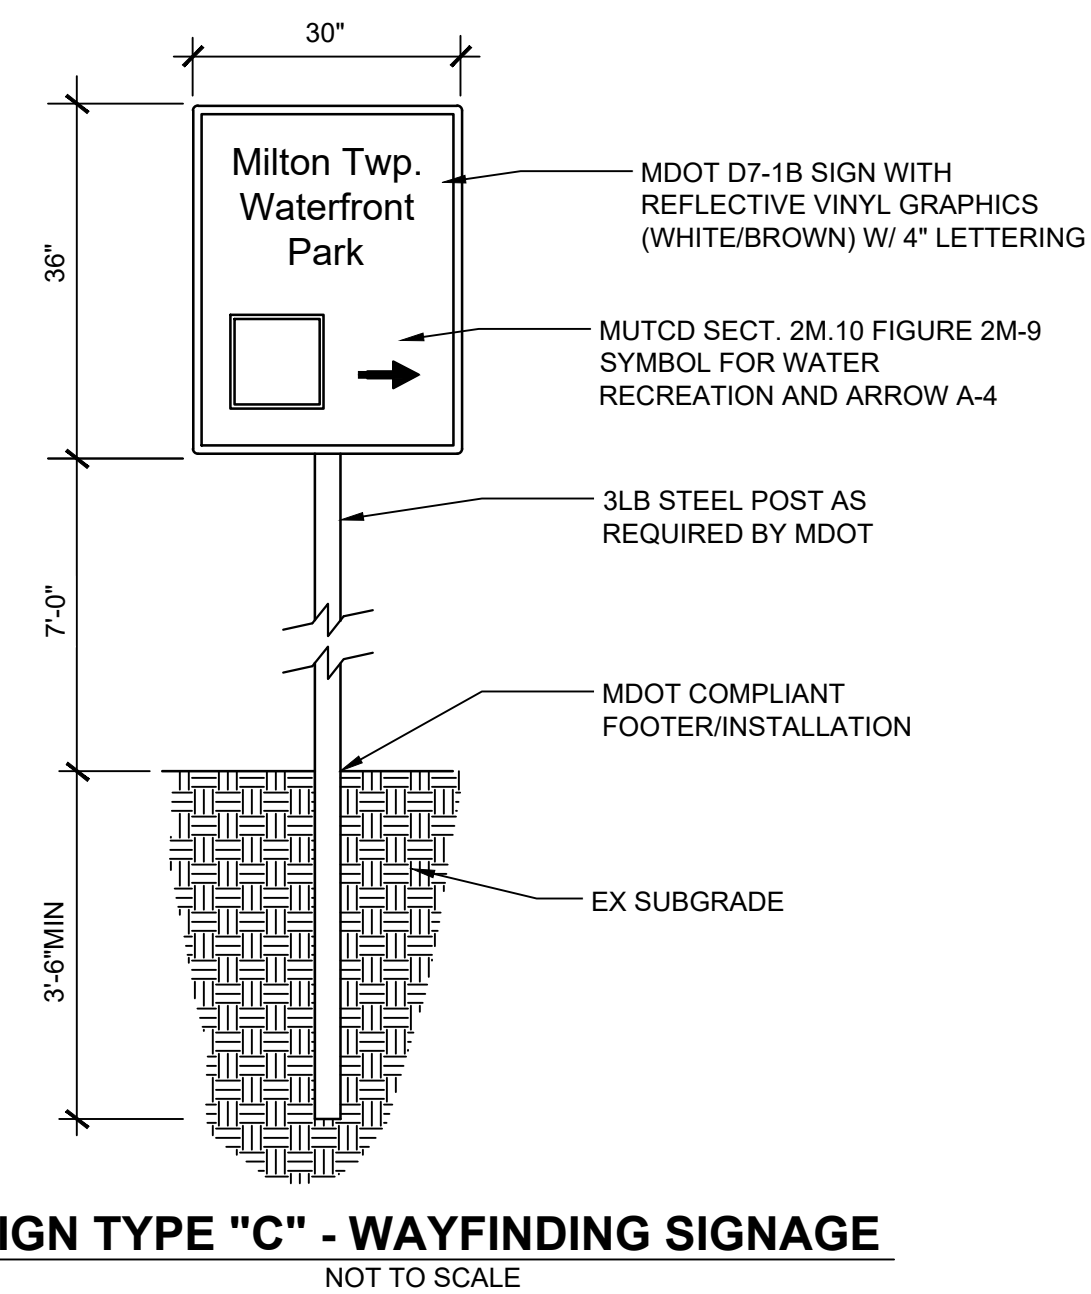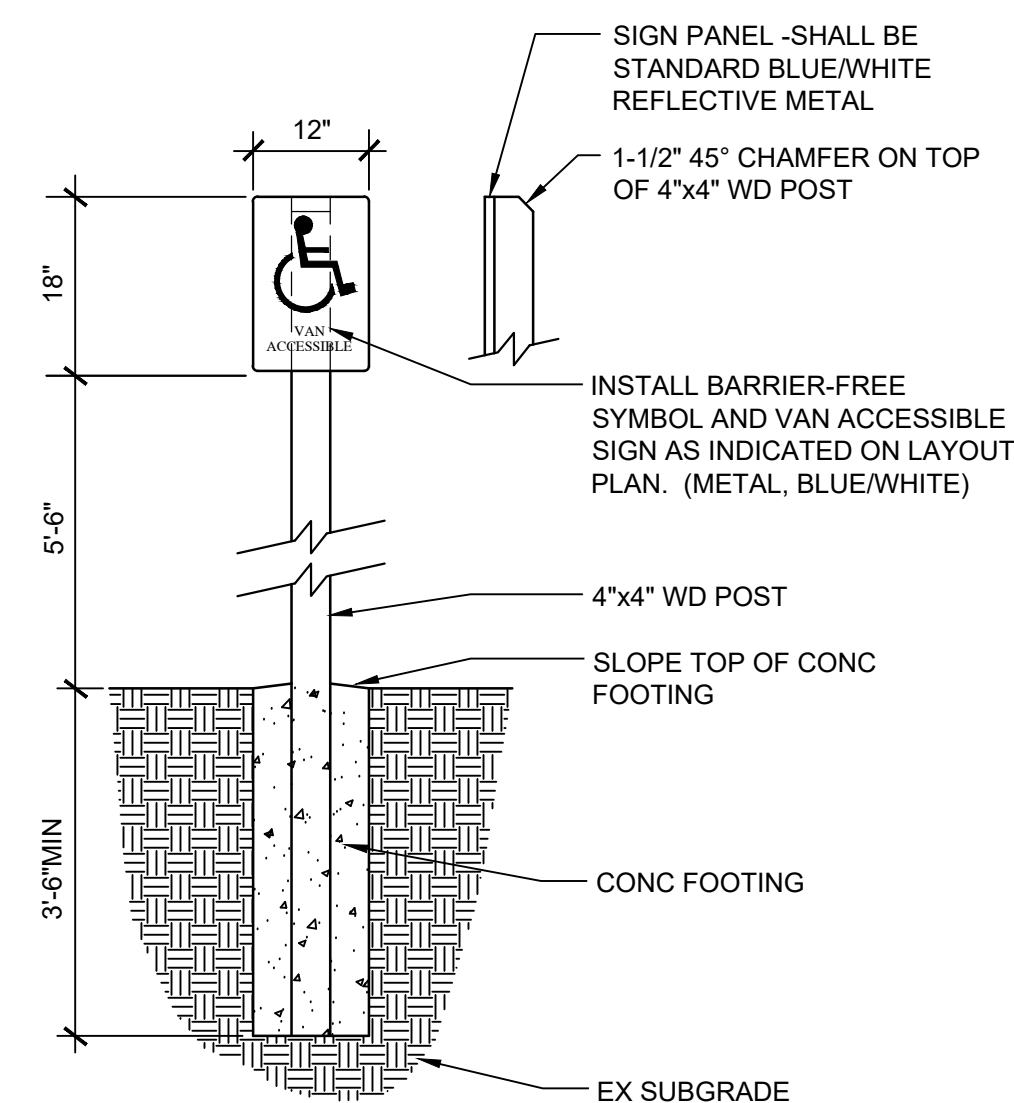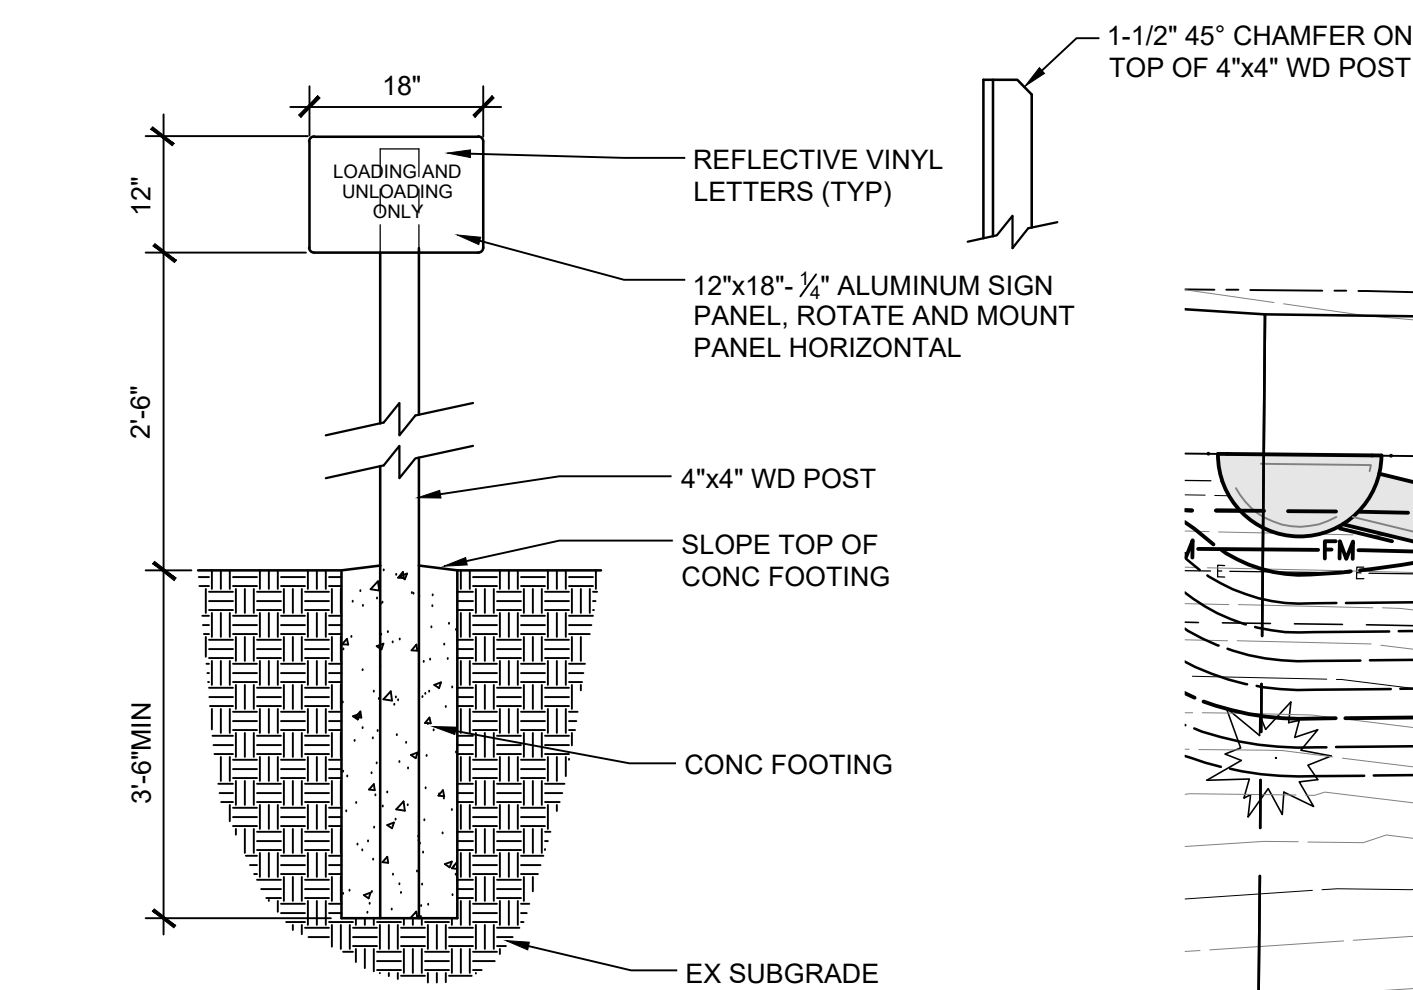

Signage Notes

1. ALL SIGNAGE LOCATED WITHIN CAIRNS HWY. RIGHT-OF-WAY SHALL CONFORM TO MMUTCD STANDARDS.
2. REMOVE AND SALVAGE ALL EXISTING SIGNAGE WITHIN THE LIMITS IF CONSTRUCTION ACTIVITIES. SALVAGED SIGNAGE SHALL REMAIN PROPERTY OF THE OWNER.
3. PREVENT DAMAGE OF SIGNAGE TO BE RELOCATED AND REUSED. IF DAMAGE TO REUSABLE SIGNAGE OCCURS DURING REMOVAL, THE CONTRACTOR SHALL REPLACE SIGNAGE OR REIMBURSE THE OWNER.
4. ALL SIGNAGE SHALL CONFORM TO ANTRIM COUNTY ROAD COMMISSION STANDARDS AND PER ALL PERMIT REQUIREMENTS.
5. ALL SIGNAGE WITHIN THE RIGHT-OF-WAY SHALL USE DIRECT DRIVEN STEEL CHANNEL POSTS, REFER TO MDOT DETAIL SIGN-200-B FOR STANDARD MATERIALS AND CONSTRUCTION.

Sign Schedule

<u>SIGN</u>	<u>TYPE</u>	<u>NOTES</u>	<u>SIDE "A"</u>	<u>QUANTITY</u>
1	A		LOADING / UNLOADING ZONE	2
2	B	SIGN SHALL BE IN COMPLIANCE WITH MMUTCD	 HANDICAP PARKING ACCESS (UTILIZE 18"x12" REGULATORY SIGN)	2
3	B	SIGN SHALL BE IN COMPLIANCE WITH MMUTCD	NO PARKING ANYTIME	1
4	C	SIGN SHALL BE IN COMPLIANCE WITH MMUTCD	WAY FINDING SIGN TO PADDLE ANTRIM TRAIL	2

General Legend

- | | |
|---|---------------------------|
|  | PROJECT LIMITS |
|  | EDGE OF WATER |
|  | EX EDGE OF GRAVEL |
|  | EX EDGE OF CONCRETE |
|  | EX OVERHEAD ELECTRIC |
|  | EX CONCRETE CURB |
|  | EX WOOD BOLLARD |
|  | EX CONIFEROUS TREE |
|  | EX DECIDUOUS TREE |
|  | PROPOSED EDGE OF ASPHALT |
|  | PROPOSED EDGE OF CONCRETE |
|  | EXISTING CONTOUR |
|  | PROPOSED CONTOUR |

Surfacing Symbol Legend

-  CONCRETE PAVING
 ASPHALT PAVING
 LANDSCAPE EDGING



Know what's below.
Call before you dig.

THE LOCATION OF THE EXISTING UTILITIES, AS SHOWN ON THIS PLAN, ARE APPROXIMATE ONLY. IT SHALL BE THE RESPONSIBILITY OF THE CONTRACTOR TO VERIFY ACTUAL LOCATION AND DEPTH OF ALL EXISTING UTILITIES. THE OWNER AND THE SURVEYOR SHALL NOT BE RESPONSIBLE FOR ANY OMISSION OR VARIATION FROM THE LOCATION SHOWN. THE CONTRACTOR SHALL NOTIFY "MISS DIG" AT 1 (800) 482-7171 OR 811 THREE (3) WORKING DAYS PRIOR TO THE START OF CONSTRUCTION.



**CIVIL ENGINEERING
SURVEYING
ENVIRONMENTAL SERVICES
GEOTECHNICAL
CONSTRUCTION SERVICES
DRILLING
LANDSCAPE ARCHITECTURE**



ML DESIGN GROUP, LTD.
25 E. 16TH STREET
RAVERSE CITY, MICHIGAN 49684


[illegible]

DEMOLITION PLAN KEWADIN WATERFRONT PARK MILTON TOWNSHIP

Date Issued:	02-12-19
Date Surveyed:	06-06-2018
Designed By:	CFC
Drawn By:	MD/MAK
Checked By:	CFC
Scale:	AS NOTED
Original sheet size is 22x34	

Location:
T. 30 N, R 09 W, SEC. 11
ELK LAKE, MILTON TWP.
ANTRIM CO., MI


Project Number:
2018528001.01

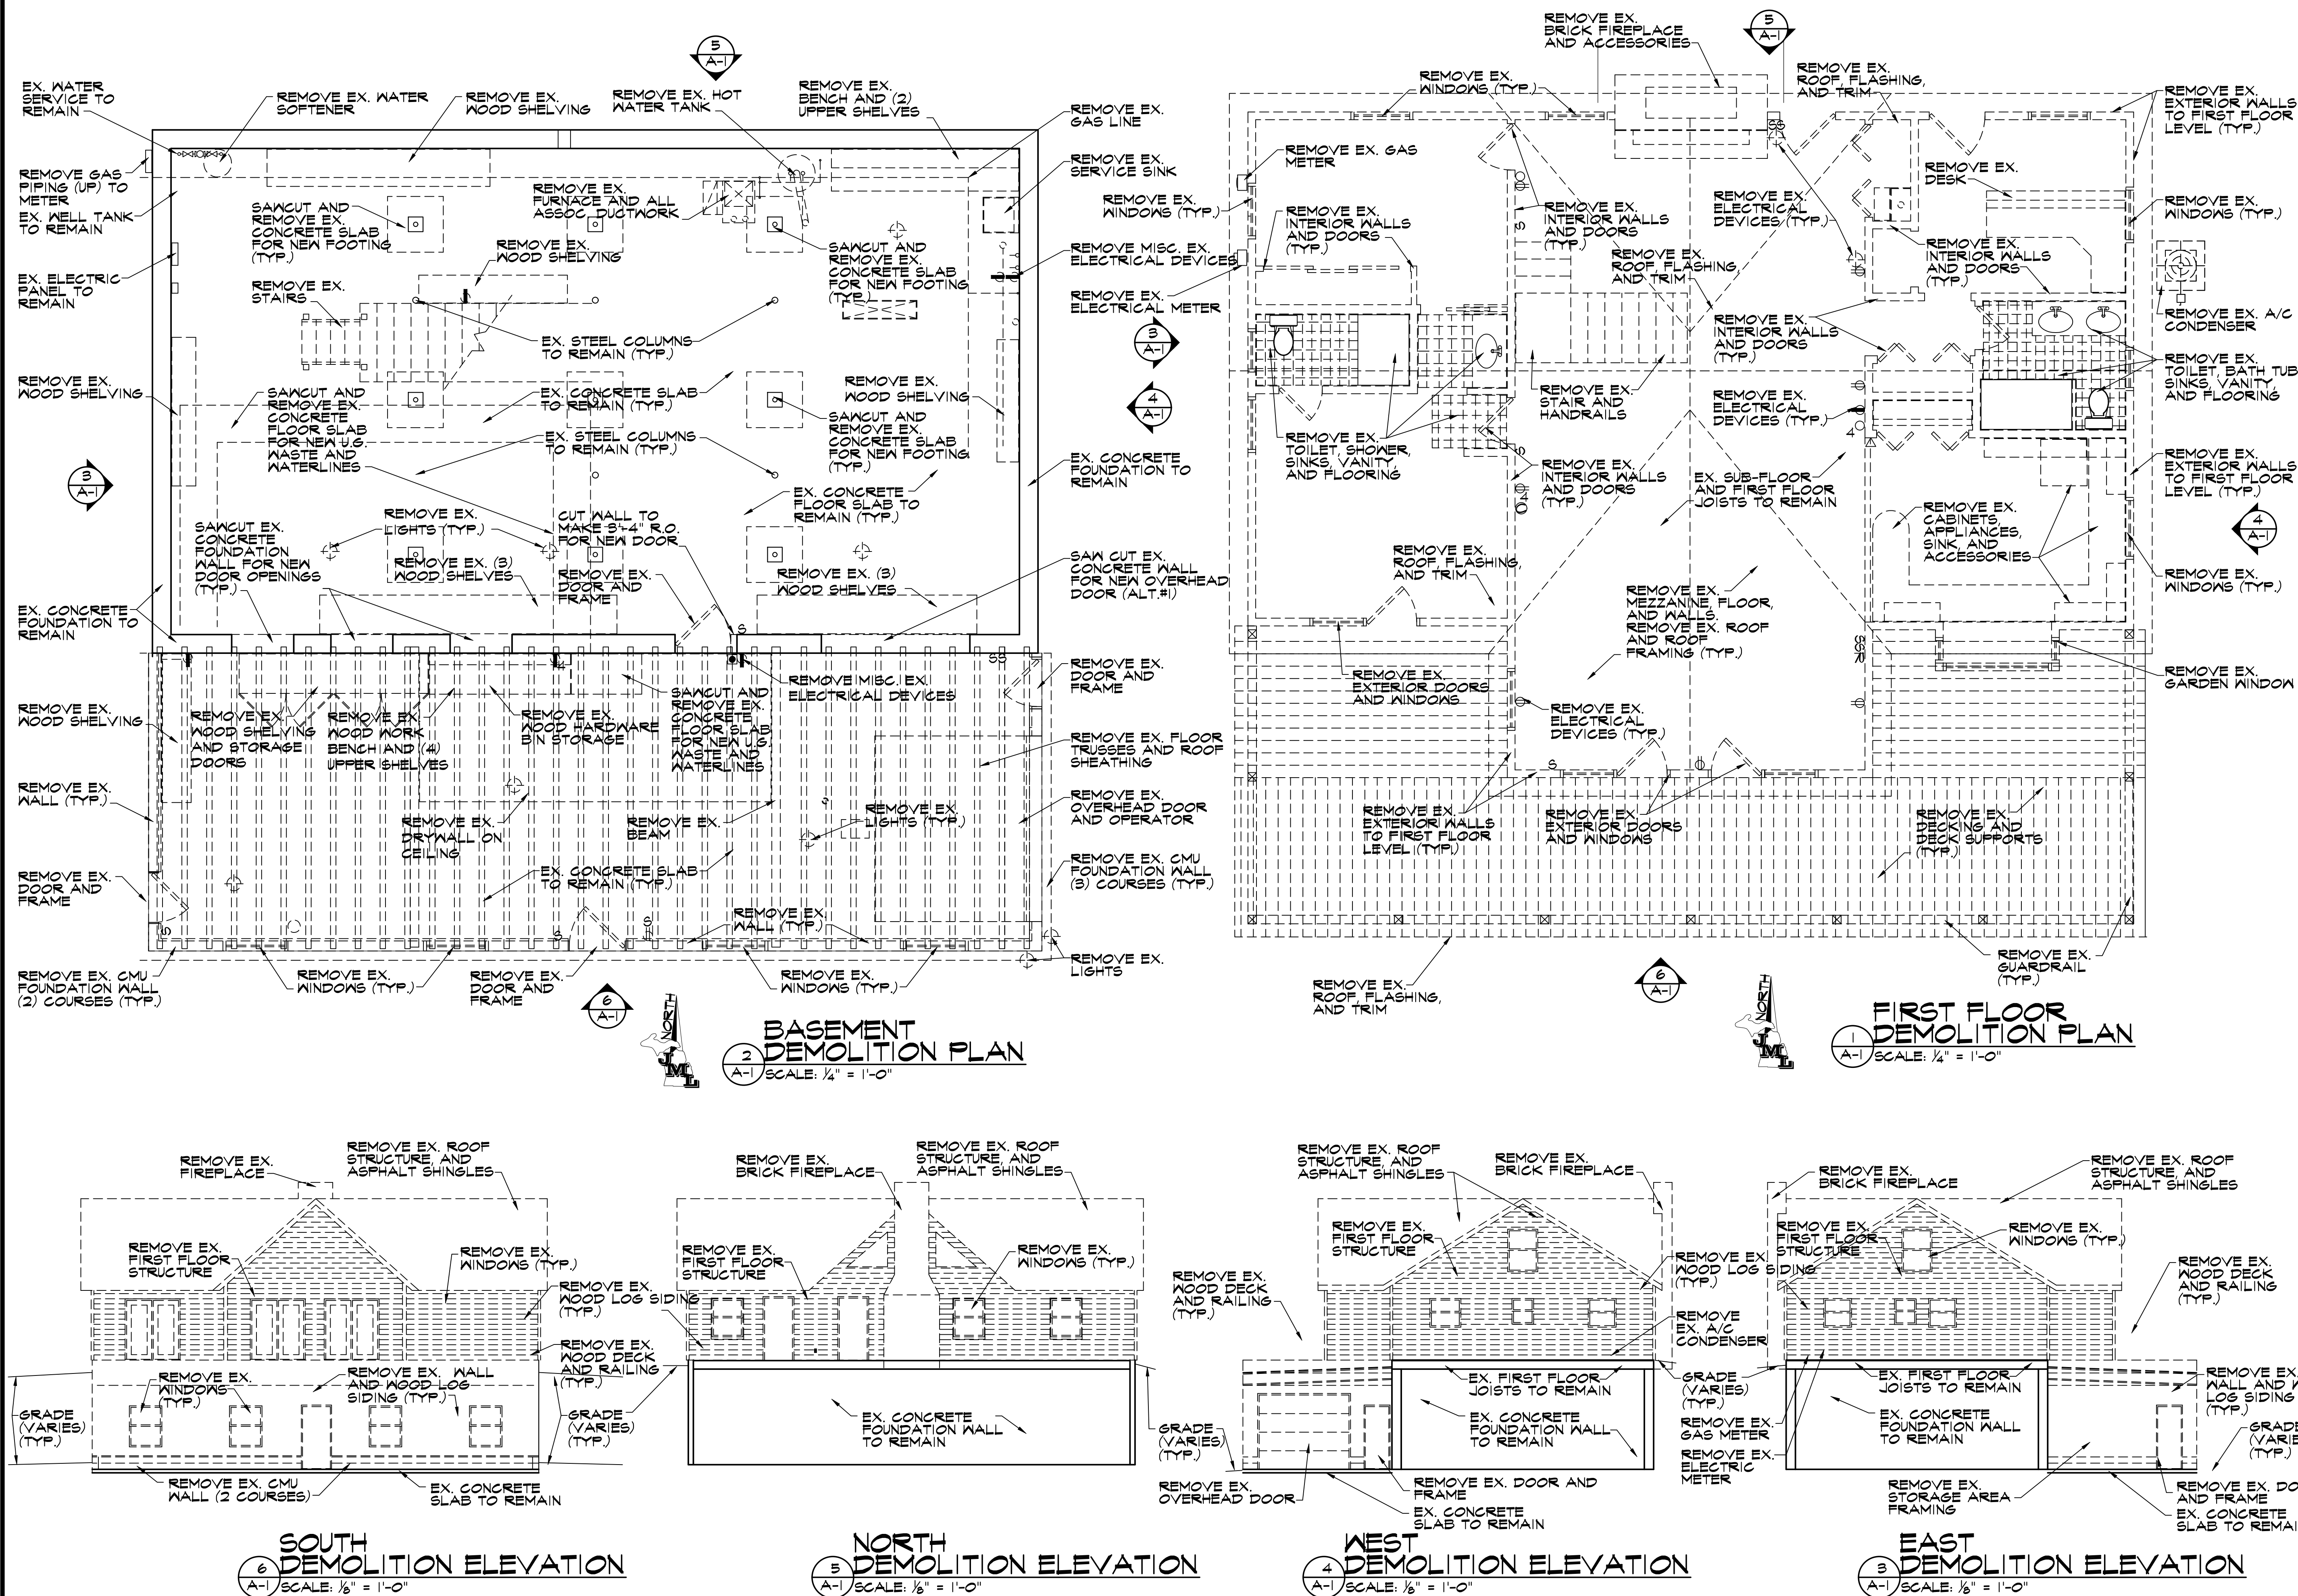Sheet: **A-1**

NO.	DOOR LOCATION	SIZE	DOOR		FRAME			LABEL	HDWR	NOTES
			TYPE	MATERIAL	MATERIAL	HEAD	JAMB			
1	UNISEX TOILET (RM. B101)	3'-0"x7'-0" x 13/4"	A	HM	HM				3	
2	JANITORS CLOSET (RM. B102)	3'-0"x7'-0" x 13/4"	A	HM	HM				1	
3	UNISEX TOILET (RM. B103)	3'-0"x7'-0" x 13/4"	A	HM	HM				3	
4	STORAGE (RM. B100)	3'-0"x7'-0" x 13/4"	A	HM	HM				1	
5	STORAGE (RM. B100)	3'-0"x8'-0"	B	INS. METAL	-				2	ALT. #1

RM. #	ROOM NAME	CEILING	CLG. HT.	WALLS				FLOORS	BASE	REMARKS
				NORTH	SOUTH	EAST	WEST			
100	PAVILION	STN-1	VARIES	-	-	-	-	CONC-1	-	
B100	STORAGE	PTD-2	10'-9"	CONC-1	CONC-1	CONC-1	CONC-1	CONC-1	-	
B101	UNISEX TOILET	PTD-2	8'-0"	PTD-1	PTD-1	PTD-1	PTD-1	EPOXY-1	VB-1	
B102	JANITOR'S CLOSET	PTD-2	8'-0"	PTD-1	PTD-1	PTD-1	PTD-1	EPOXY-1	VB-1	
B103	UNISEX TOILET	PTD-2	8'-0"	PTD-1	PTD-1	PTD-1	PTD-1	EPOXY-1	VB-1	

NOT TO SCALE

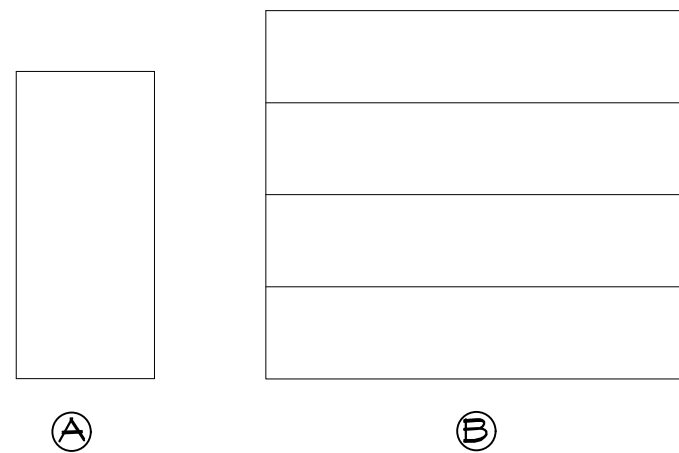

SET #1:

- 1/2" PAIR HINGES
(1) LEVER PASSAGE SET
(1) CYLINDER LOCK
W/THUMBTURN
(1) CLOSER
WEATHERSTRIPPING

SET #2:


OVERHEAD DOOR TRACKS AND HARDWARE
(BY DOOR MFR)

SET #3:

- 1/2" PAIR HINGES
- (1) LEVER PASSAGE SET
- (1) ELECTRIC STRIKE
- (1) CLOSER
- (1) POWER SUPPLY
- (1) TIMER

GA. FILE NO. FC 5724: PROPRIETARY 2 HOUR FIRE

APPROX. CEILING WEIGHT: 6 PSF
FIRE TEST: UL R2T17-35, 10-21-64,
UL DESIGN L505;
ULC DESIGN M503

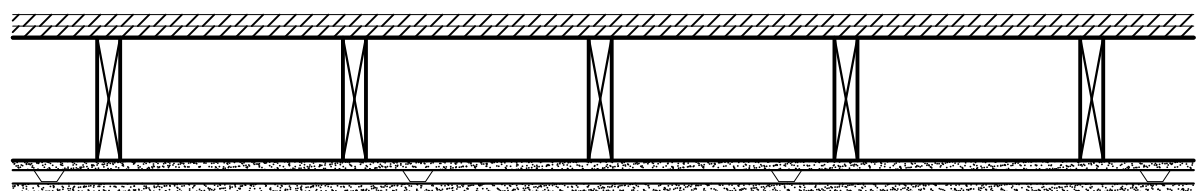

CONSTRUCTION TYPE: WOOD FLOOR, WOOD JOISTS, GYPSUM WALLBOARD,
RESILIENT CHANNELS

BASE LAYER 5/8" PROPRIETARY TYPE "X" GYPSUM WALLBOARD OR GYPSUM VENEER BASE APPLIED AT RIGHT ANGLES TO 2" TO WOOD JOISTS 12" O.C. WITH 2d NAILS 2" HEADS
 1" O.C. RESILIENT FURRING CHANNELS 2 1/4" LONG 2" O.C. FILLED AT RIGHT ANGLES TO JOISTS THROUGH BASE LAYER WITH ONE 8d NAIL 2" HEADS 1 1/4" SHANK 1 3/4" HEAD AT EACH JOIST FACE LAYER 5/8" PROPRIETARY TYPE "X" GYPSUM WALLBOARD OR GYPSUM VENEER BASE APPLIED AT RIGHT ANGLES TO RESILIENT FURRING CHANNELS WITH 1" TYPE "S" DRYWALL SCREWS 12" O.C. DOUBLE CHANNEL INSTALLED AT FACE LAYER END JOINTS, WOOD JOISTS SUPPORTING 1" NOMINAL T&G WOOD SUBFLOOR AND 1" NOMINAL WOOD FINISH FLOOR OR 3/4" PLYWOOD FINISHED FLOOR WITH LONG EDGES T&G AND 1 1/2" INTERIOR PLYWOOD WITH EXTERIOR GLUE SUBFLOOR PERPENDICULAR TO JOISTS WITH JOINTS STAGGERED.

PROPRIETARY GYPSUM BOARD		
CERTAIN TEED GYPSUM INC.	-	3/8" CERTAIN TEED® TYPE C GYPSUM BOARD
CONTINENTAL BUILDING PRODUCTS	-	3/8" FIRECHECK® TYPE C
GEORGIA-PACIFIC GYPSUM LLC	-	3/8" TOUGHROCK FIREGUARD C® GYPSUM BOARD
NATIONAL GYPSUM COMPANY	-	5/8" GOLD BOND R BRAND FIRE-SHIELD C GYPSUM WALLBOARD
PABCO GYPSUM	-	3/8" FLAME CURB® SUPER "C"

(A-3) NOT TO SCALE

GA. FILE NO. CM 2803:	GENERIC	2 HOUR FIRE
GYPSUM WALLBOARD, STEEL STUDS		

BASE LAYER $\frac{1}{8}$ " TYPE X GYPSUM WALLBOARD APPLIES WITHOUT HORIZONTAL JOINTS TO 15" (38 MIL. (25 GA.) STEEL STUDS LOCATED AT EACH CORNER OF 158X86 @ 250 TYPE STEEL COLUMN WITH 1" TYPE S DRYWALL SCREWS 24" O.C. SECOND LAYER $\frac{1}{8}$ " TYPE X GYPSUM BOARD WITHOUT HORIZONTAL JOINTS WITH 13/4" TYPE S DRYWALL SCREWS 12" O.C. AND WIRE TIED WITH 18 GA WIRE 24" O.C. FACE LAYER $\frac{1}{8}$ " TYPE X GYPSUM WALLBOARD APPLIED WITHOUT HORIZONTAL JOINTS TO STUDS WITH 2 1/2" TYPE S DRYWALL SCREWS 12" O.C. METAL CORNERBEAD APPLIED TO ALL CORNERS WITH 1" DRYWALL SCREWS 12" O.C. IN EACH FLANGE. JOINT COMPOUND $\frac{1}{8}$ " THICK APPLIED OVER CORNERBEAD.

(A-3) NOT TO SCALE

SHINGLES: ASPHALT SHINGLES TO BE 40 YR.
ARCHITECTURAL GRADE CERTAINTIED OR
APPROVED EQUAL. COLOR TO BE
DETERMINED

STN-1: TREATED LUMBER TO BE STAINED W/ OPAQUE STAIN. STAIN TO BE ONE COAT SIKKENS CETOL SRD OR APPROVED EQUAL

T-III AND IX2 BATTENS TO BE STAINED. STAIN
TO BE ONE COAT SIKKENS CETOL SRD OR
APPROVED EQUAL


VINYL SIDING TO BE MASIC QUEST
CERTAINTTEED MONOGRAM OR APPROVED
EQUAL. COLOR TO BE DETERMINED



PTD-1: PAINT TO BE ONE COAT PRIMER, ONE COAT FINISH. PAINT TO BE SEMI-GLOSS OR EPOXY. COLOR TO BE DETERMINED.

PTD-2: PAINT TO BE ONE COAT PRIMER, ONE COAT
FINISH. PAINT TO BE FLAT, CEILING WHITE.

EPOXY: EPOXY TO BE (2) COAT PLUS SEALER. COLOR TO BE DETERMINED.






VB-1: VINYL BASE TO BE ROPPE OR APPROVED
EQUAL. COLOR TO BE DETERMINED.

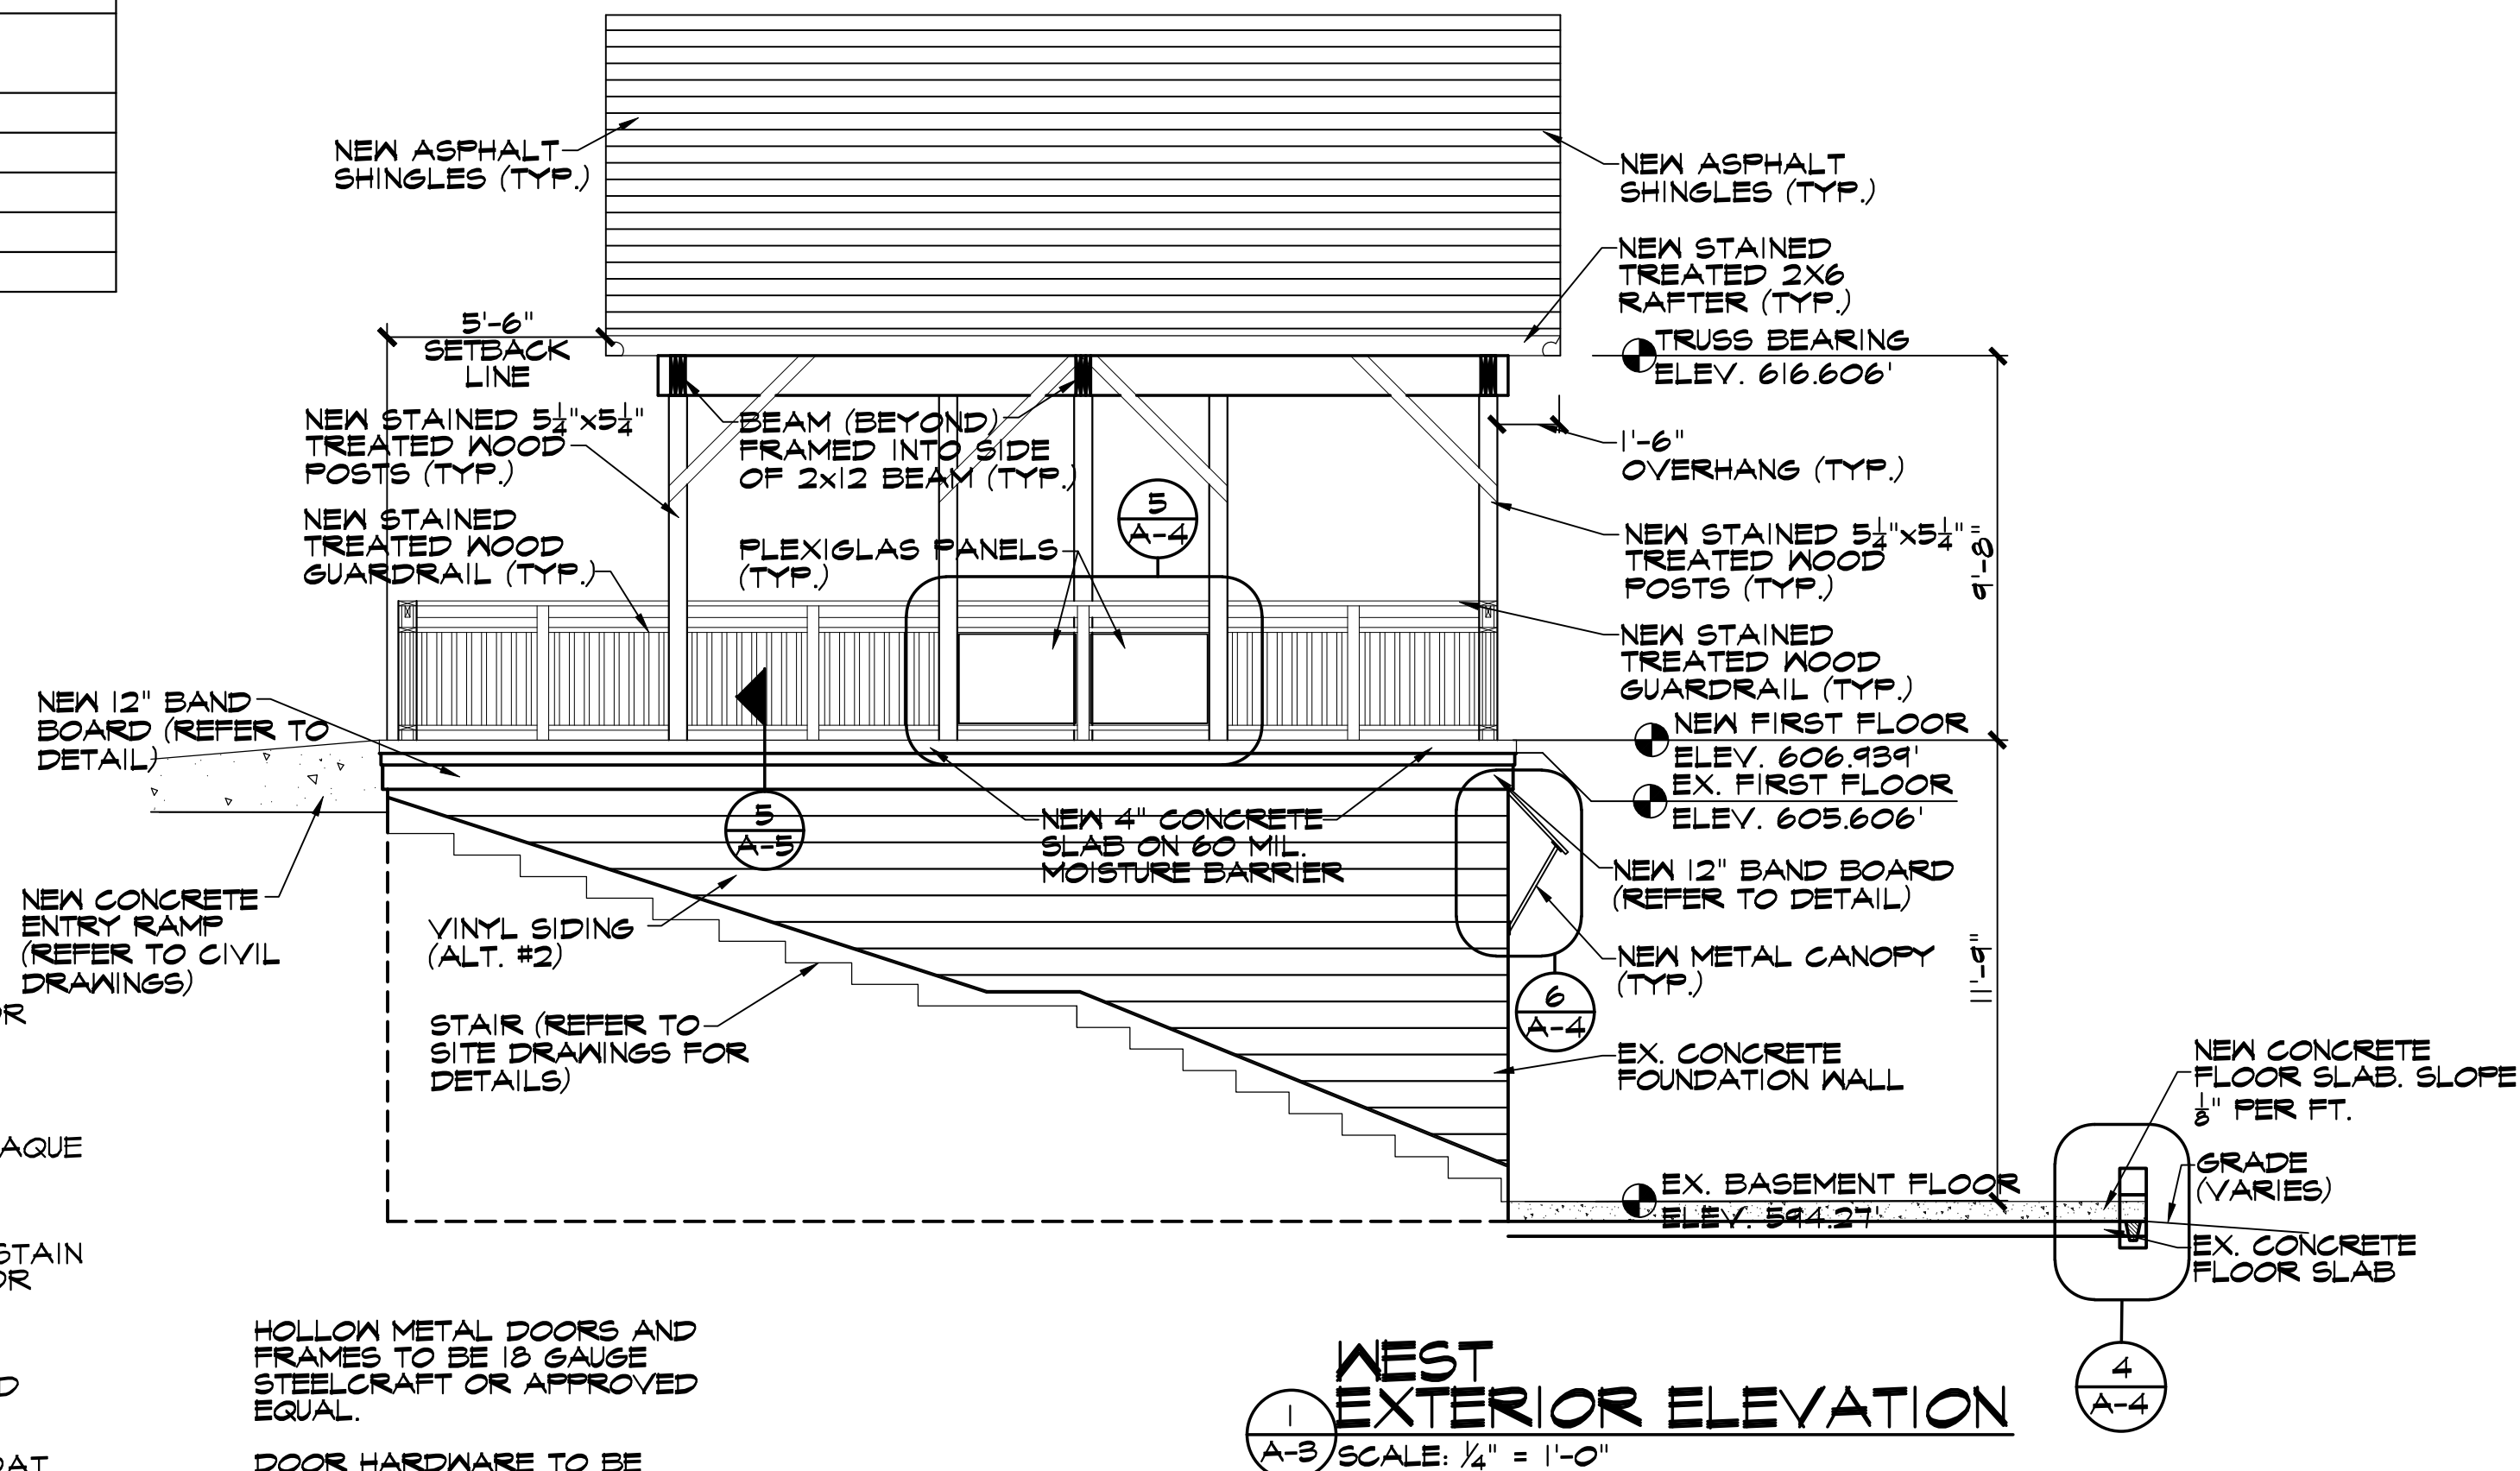

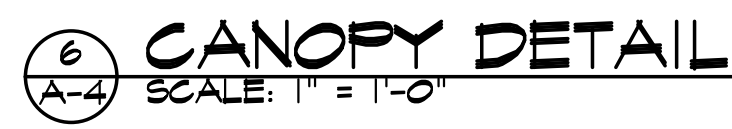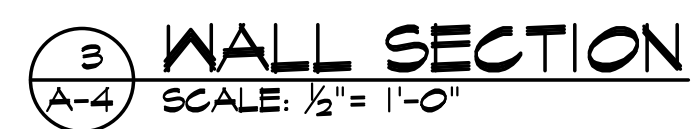

No.	Date	Revision	By

BUILDING SECTIONS
KEWADIN WATERFRONT PARK
MILTON TOWNSHIP

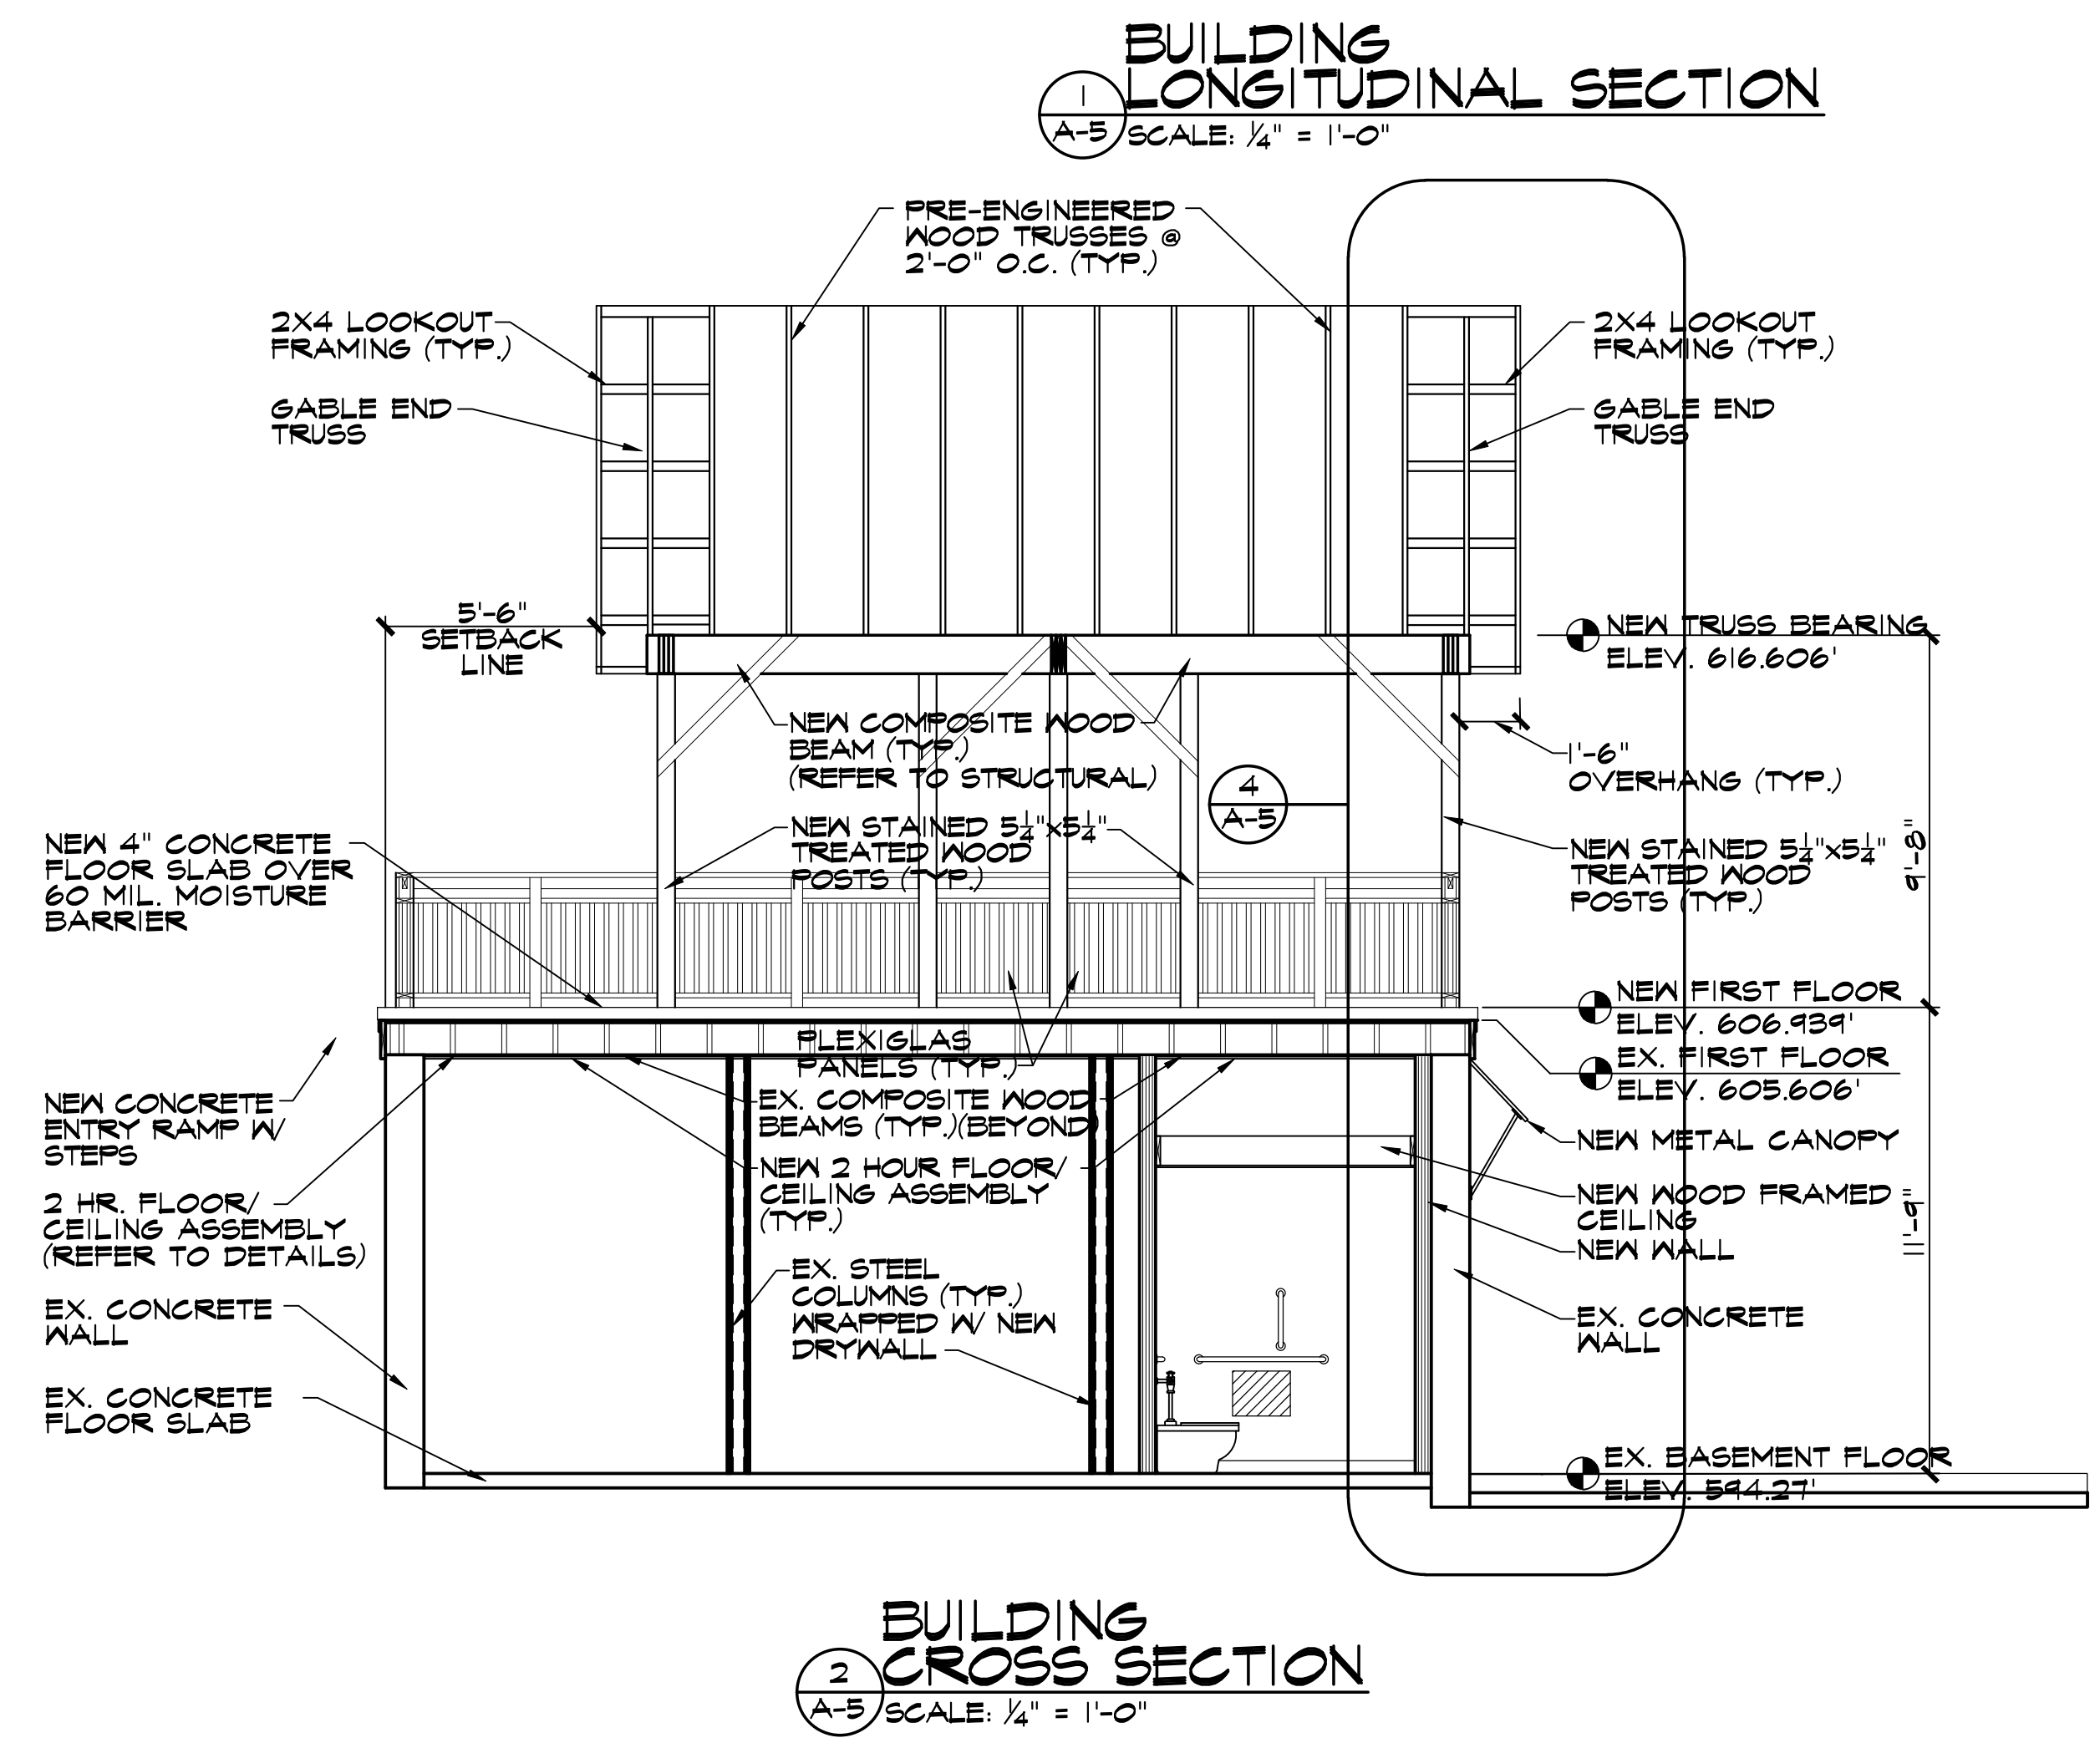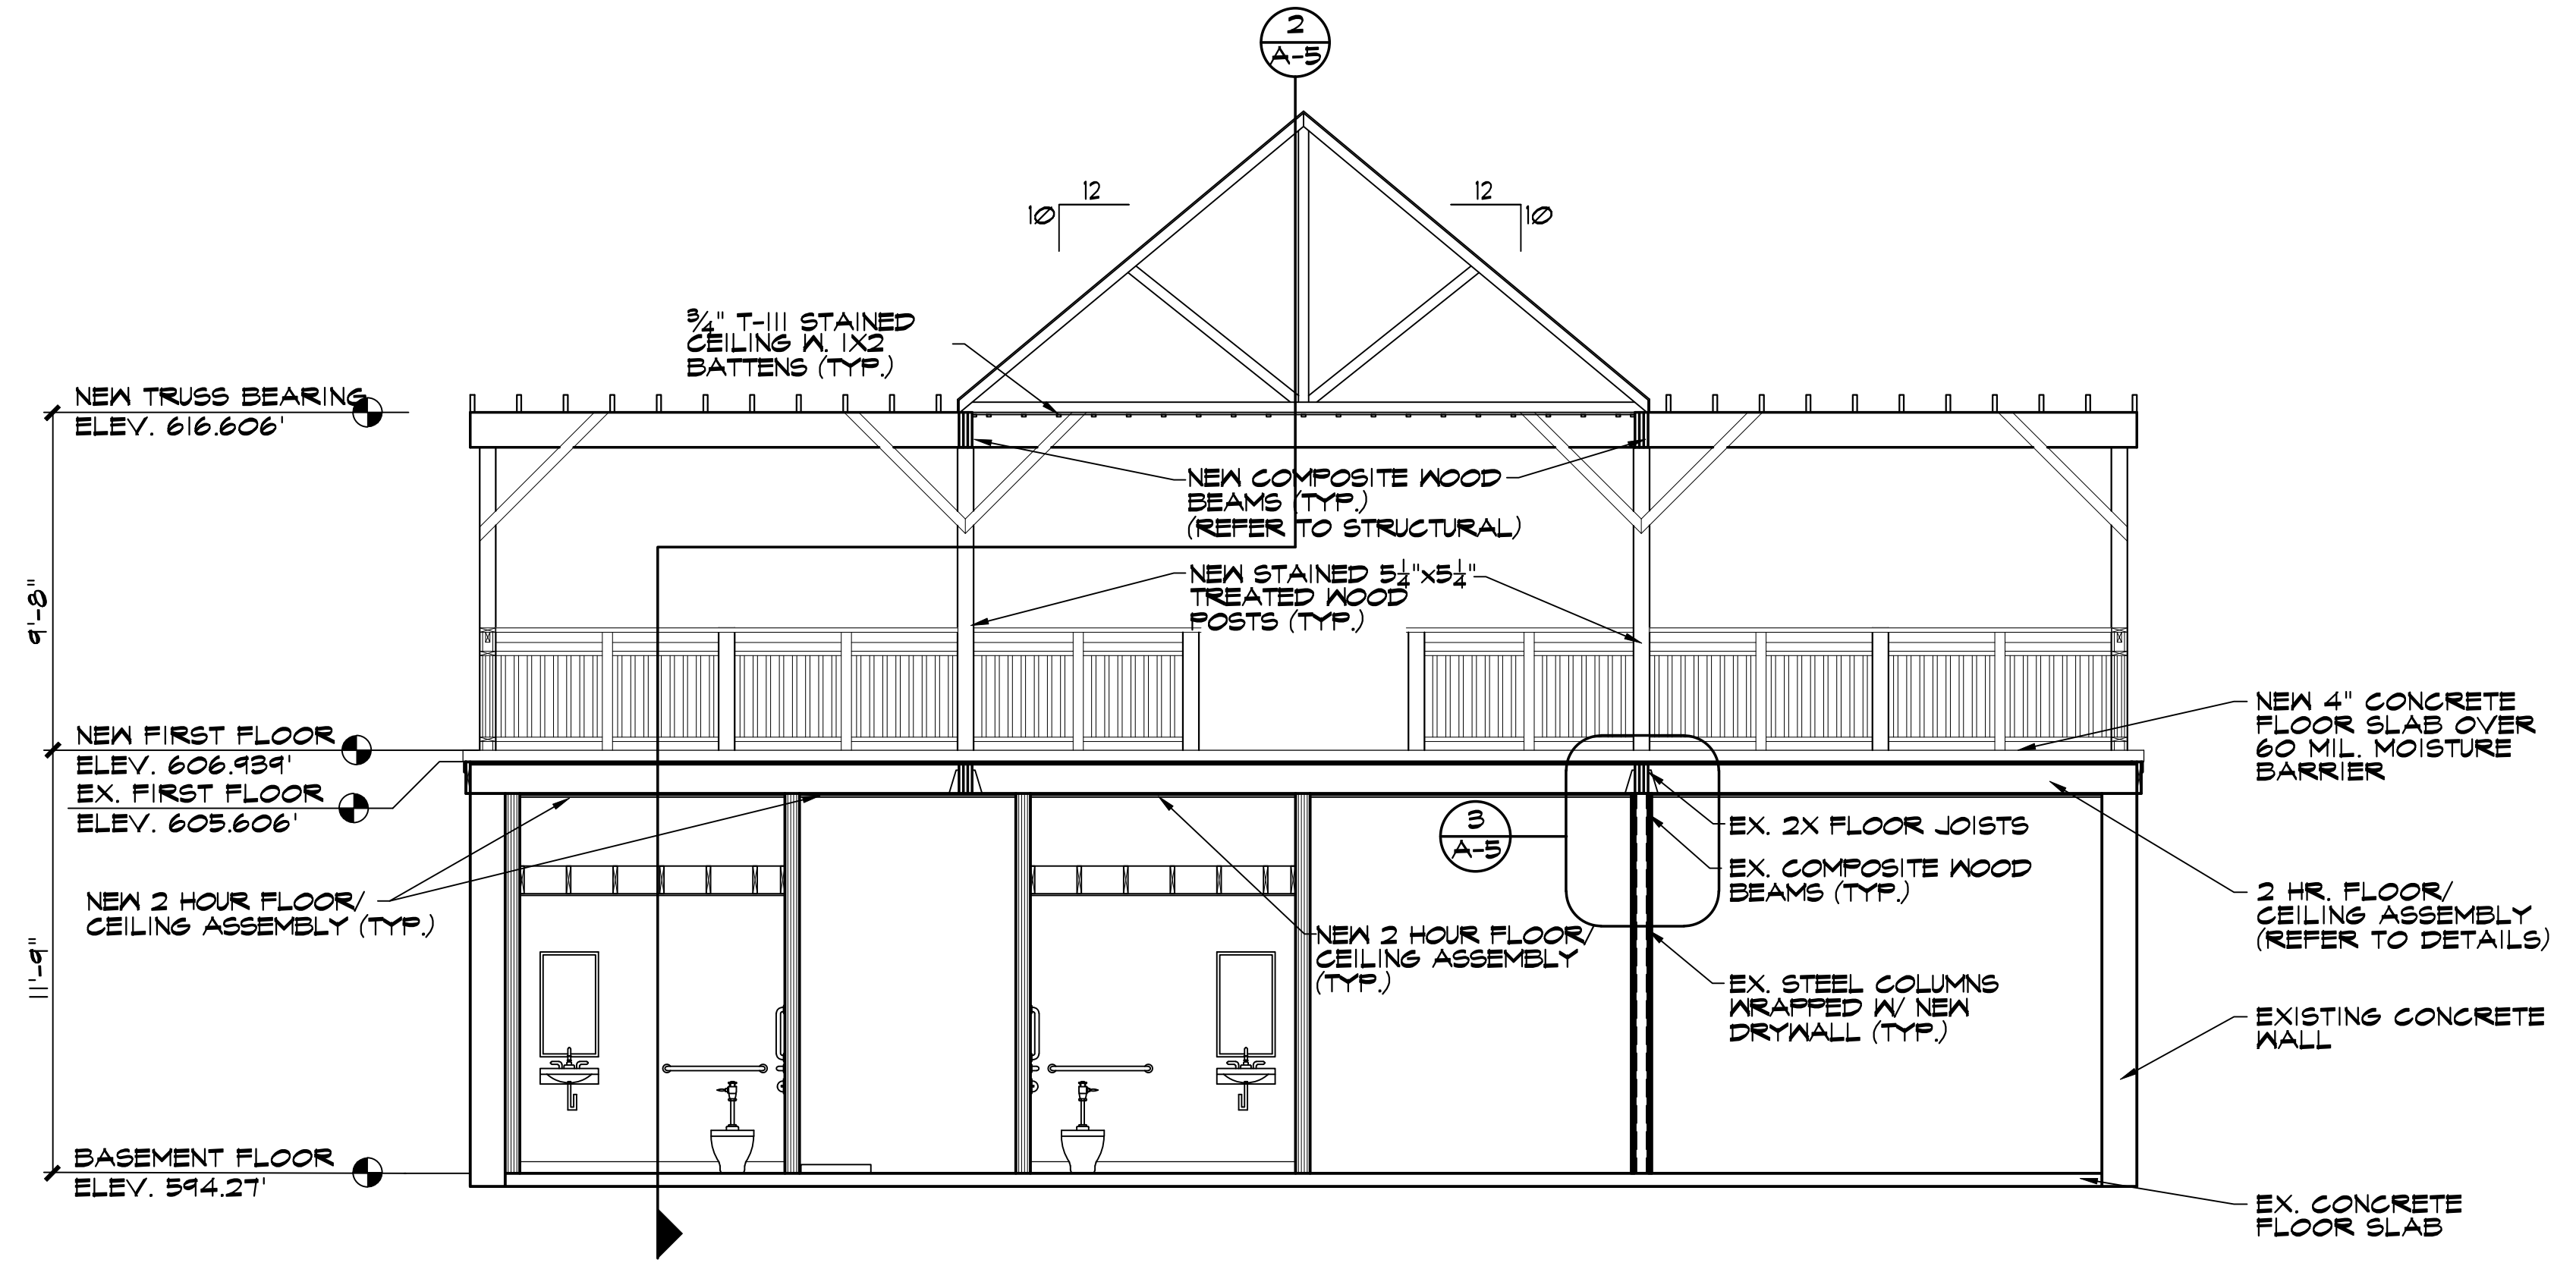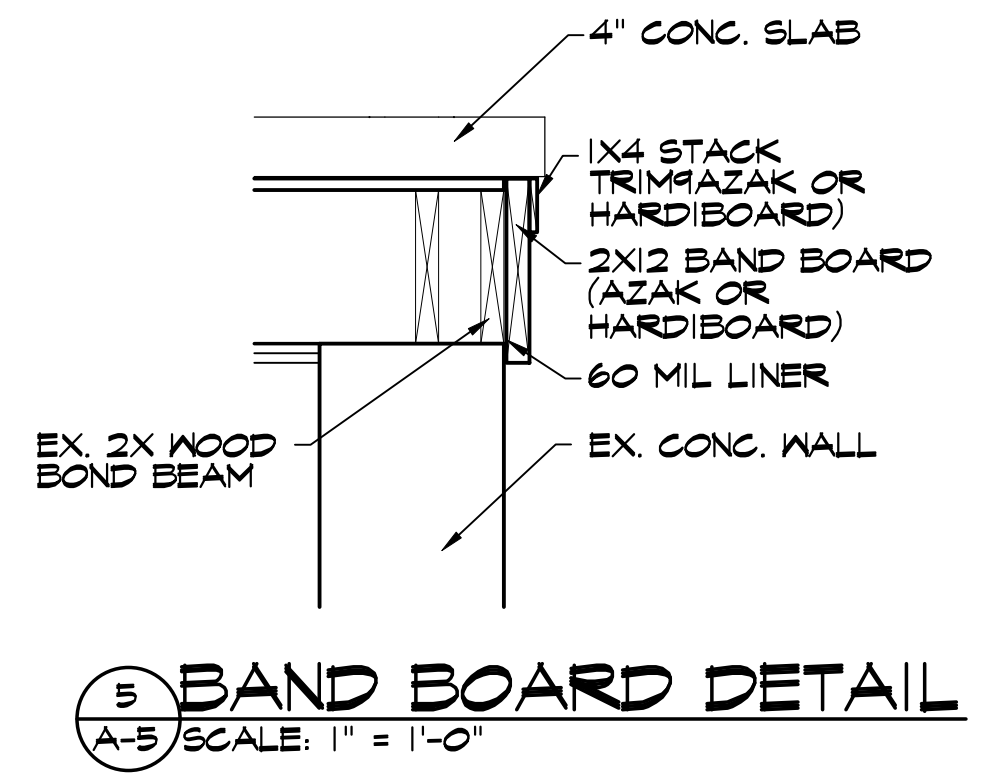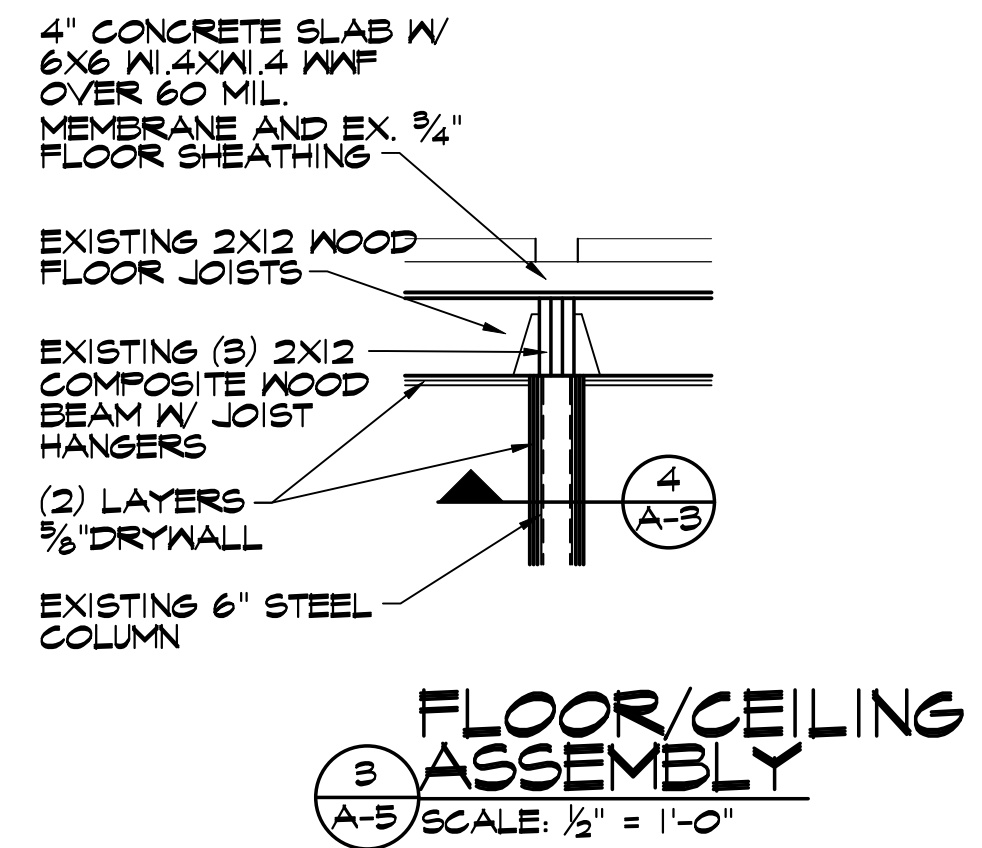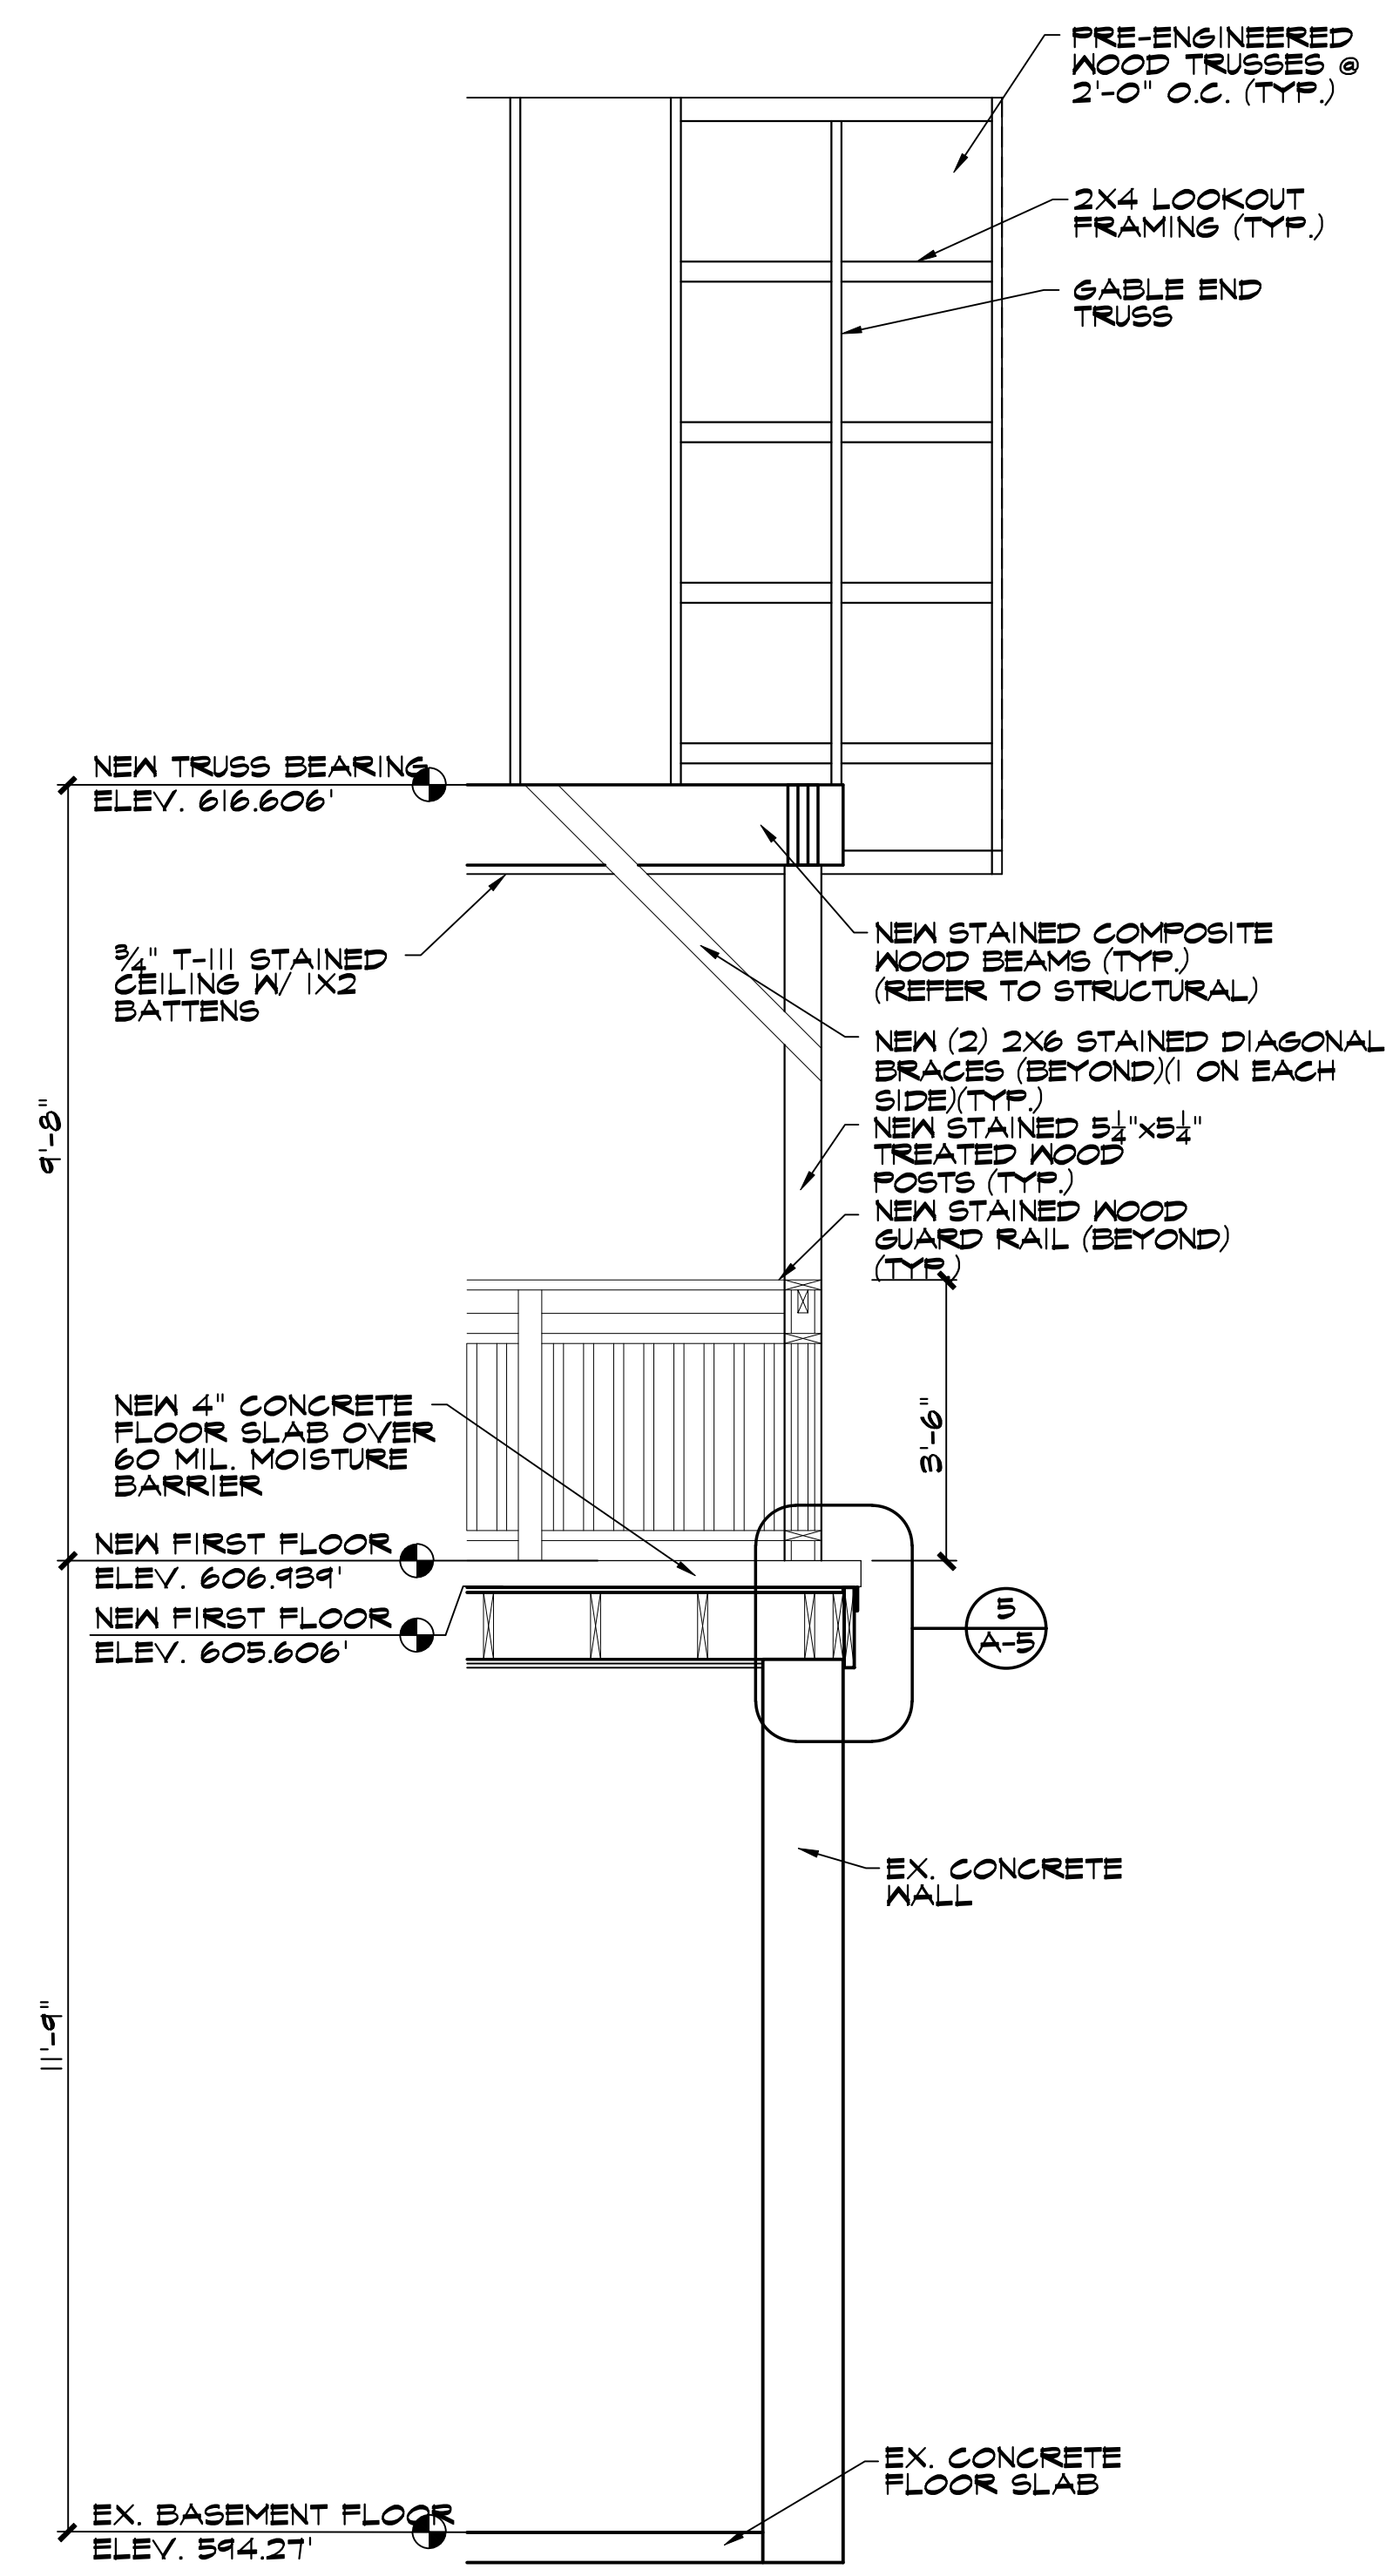



**CIVIL ENGINEERING
SURVEYING
ENVIRONMENTAL SERVICES
GEOTECHNICAL
CONSTRUCTION SERVICES
DRILLING
LANDSCAPE ARCHITECTURE**



ML DESIGN GROUP, LTD.
225 E. 16TH STREET
TRAVERSE CITY, MICHIGAN 49684

[illegible]

TOILET DETAILS KKEWADIN WATERFRONT PARK MILTON TOWNSHIP



Date Issued: 02-12-19
Date Surveyed: 06-06-2018
Designed By: CFC
Drawn By: MD/MAK
Checked By: CFC
Scale: AS NOTED

Location:
T. 30 N, R 09 W, SEC. 11
ELK LAKE, MILTON TWP.
ANTRIM CO., MI

Project Number:
2018528001.01

Sheet:

A-6

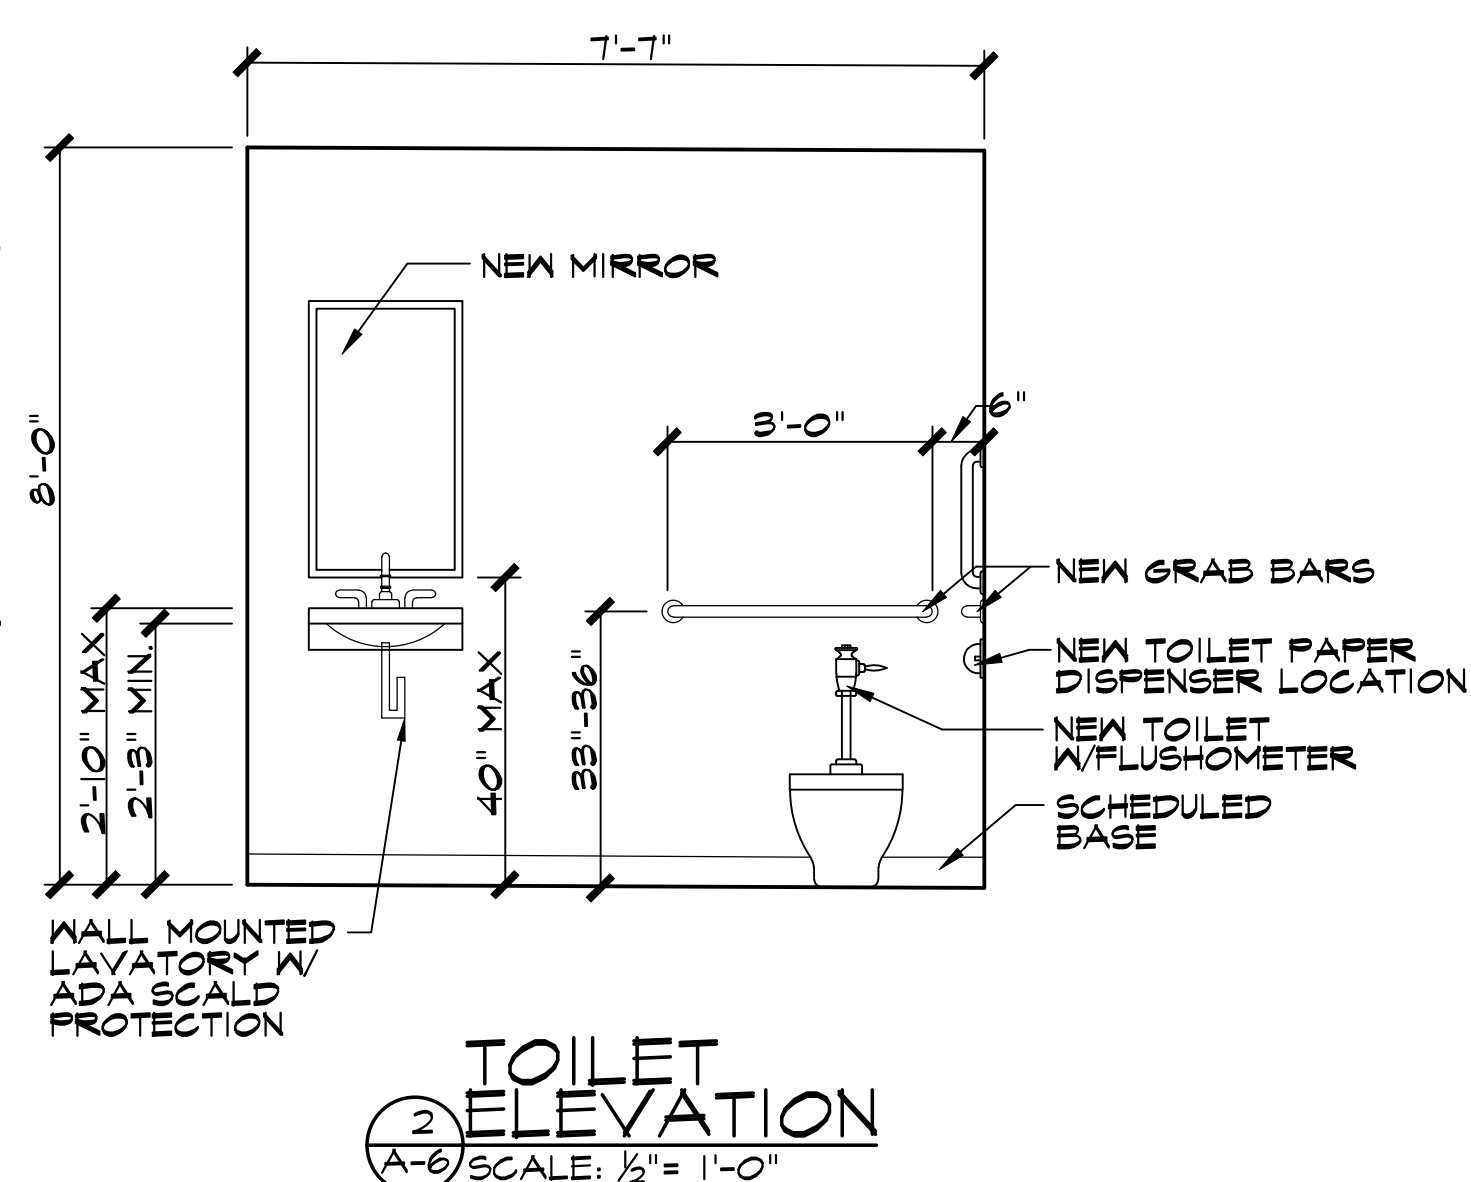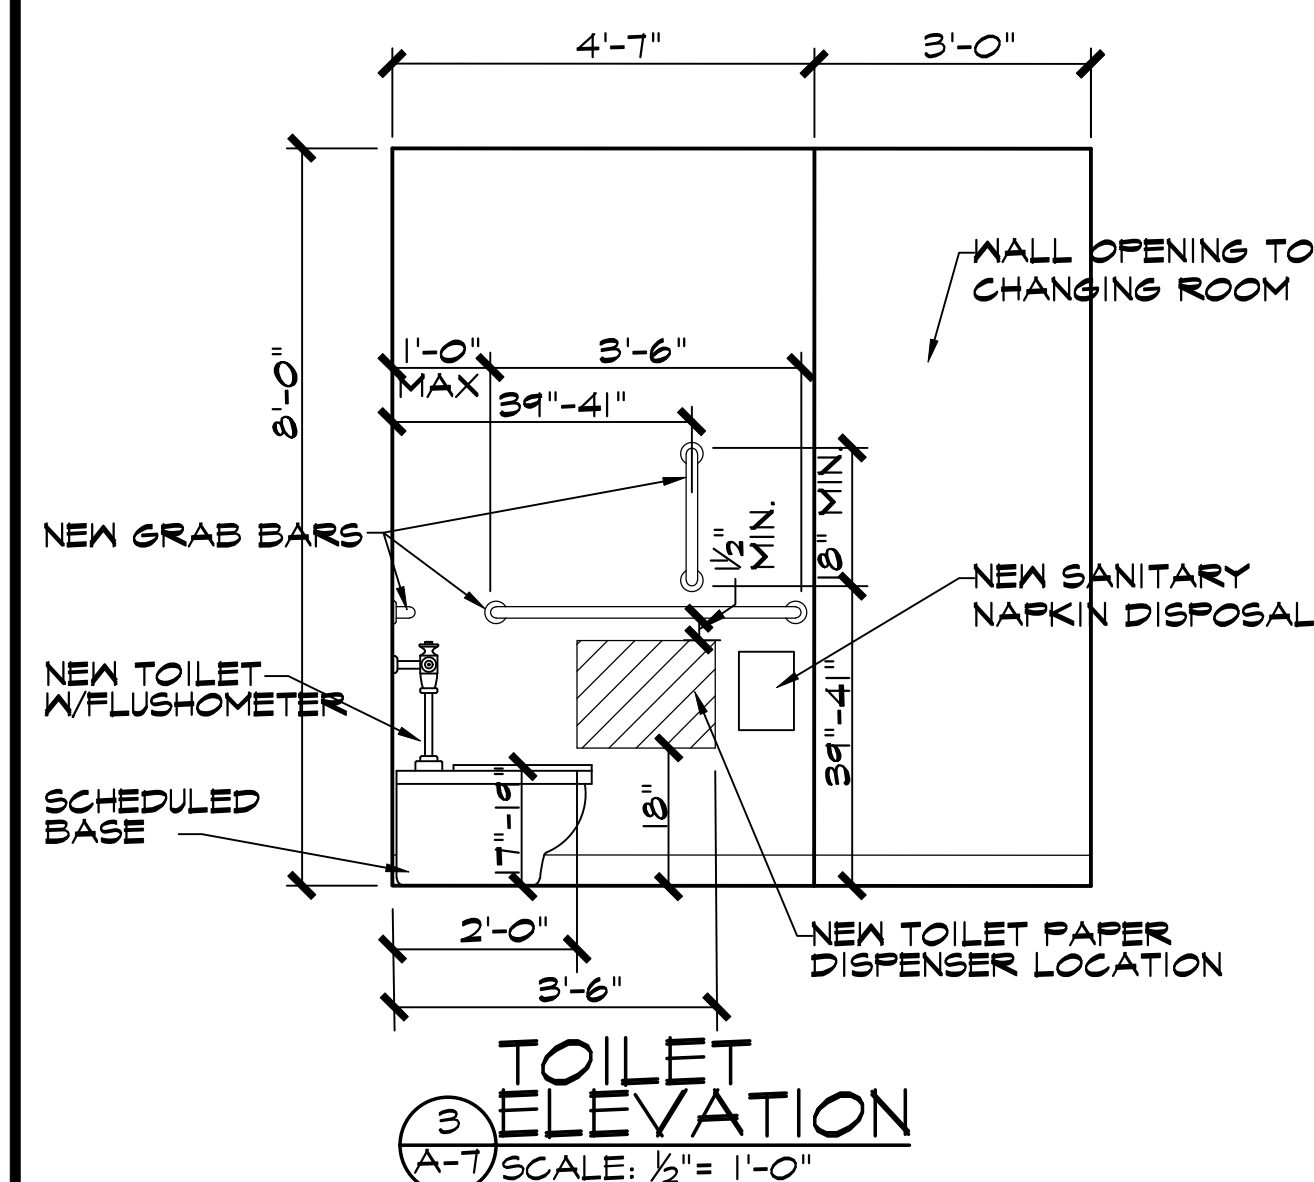

NOTE:
PROVIDE SOLID
BACKING FOR ALL
TOILET ACCESSORIES

TOILET ACCESSORIES:



TOILET PAPER DISPENSER TO BE BOBRICK, B-4288
SURFACE MOUNTED STAINLESS STEEL.

MIRROR TO BE FRAMELESS FLOAT GLASS W/ 15
YEAR WARRANTY.

SANITARY NAPKIN DISPOSAL TO BE BOBRICK
B-254. SURFACE MOUNTED SATIN STAINLESS STEEL

SOAP DISPENSER TO BE GOJO 8500-01 WALL MOUNTED SYSTEM, CHROME.

GRAB BARS TO BE STAINLESS STEEL BOBRICK
B-6806

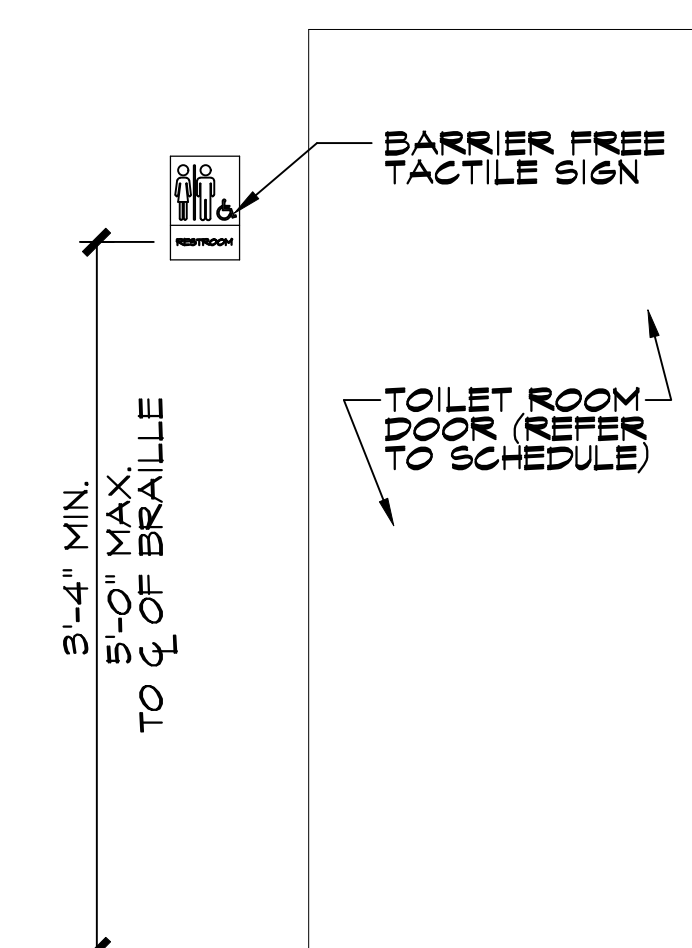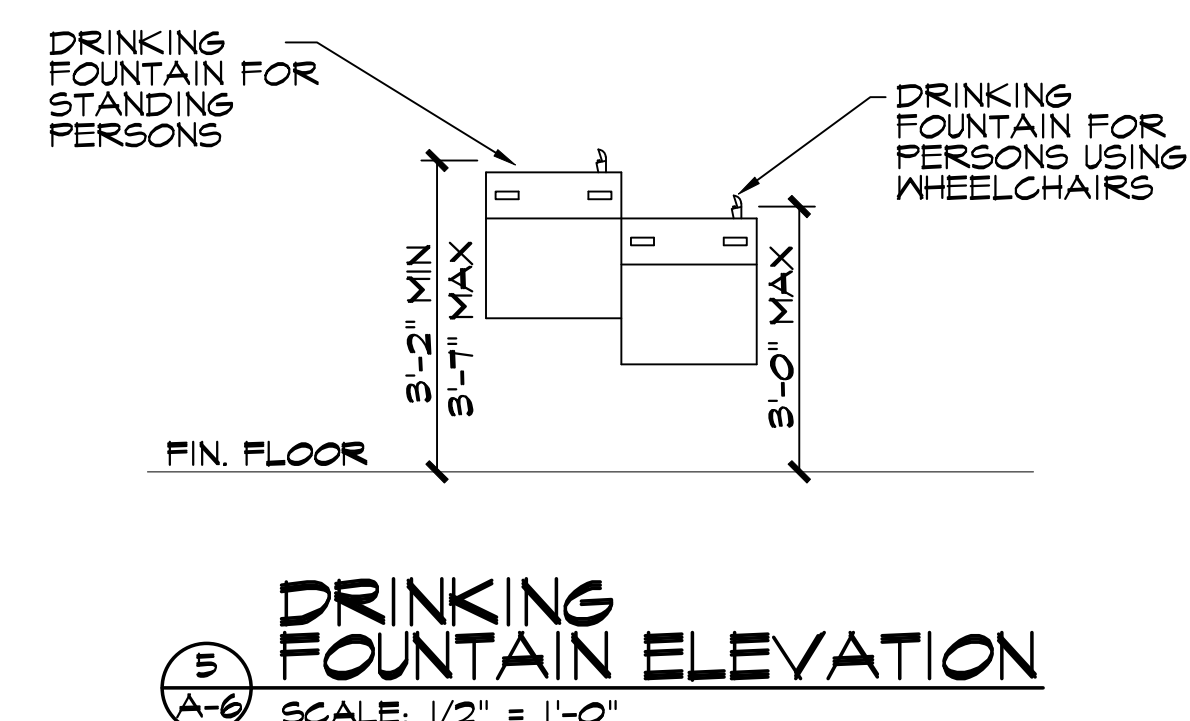

BARRIER FREE
SIGNAGE DETAIL
4
A-6 NOT TO SCALE



**CIVIL ENGINEERING
SURVEYING
ENVIRONMENTAL SERVICES
GEOTECHNICAL
CONSTRUCTION SERVICES
DRILLING
LANDSCAPE ARCHITECTURE**

ML DESIGN GROUP, LTD.
225 E. 16TH STREET
TRAVERSE CITY, MICHIGAN 49684

[illegible]

FOUNDATION PLAN
KEWADIN WATERFRONT PARK
MILTON TOWNSHIP

Date Issued: 02-12-19
Date Surveyed: 06-06-2018
Designed By: CFC
Drawn By: MD/MAK
Checked By: CFC
Scale: AS NOTED

Location:
T. 30 N, R 09 W, SEC. 11
ELK LAKE, MILTON TWP.
ANTRIM CO., MI

Project Number:
2018528001.01

Sheet: **ST-1**

P:\2018528001.00\CADD-Data\C3D\Architects Files\S-2 ROOF FRAMING PLAN.dwg Tab: Model Saved by: jlm Lumley 2/13/2019 9:03 AM Plotted by: jlm Lumley 2/13/2019 9:05 AM



**CIVIL ENGINEERING
SURVEYING
ENVIRONMENTAL SERVICES
GEOTECHNICAL
CONSTRUCTION SERVICES
DRILLING
LANDSCAPE ARCHITECTURE**





JML DESIGN GROUP, LTD.
225 E. 16TH STREET
TRAVERSE CITY, MICHIGAN 49684

[illegible]

MECHANICAL PLAN
KEWADIN WATERFRONT PARK
MILTON TOWNSHIP

Original sheet size is 22x34

Project Number:
2018528001.01

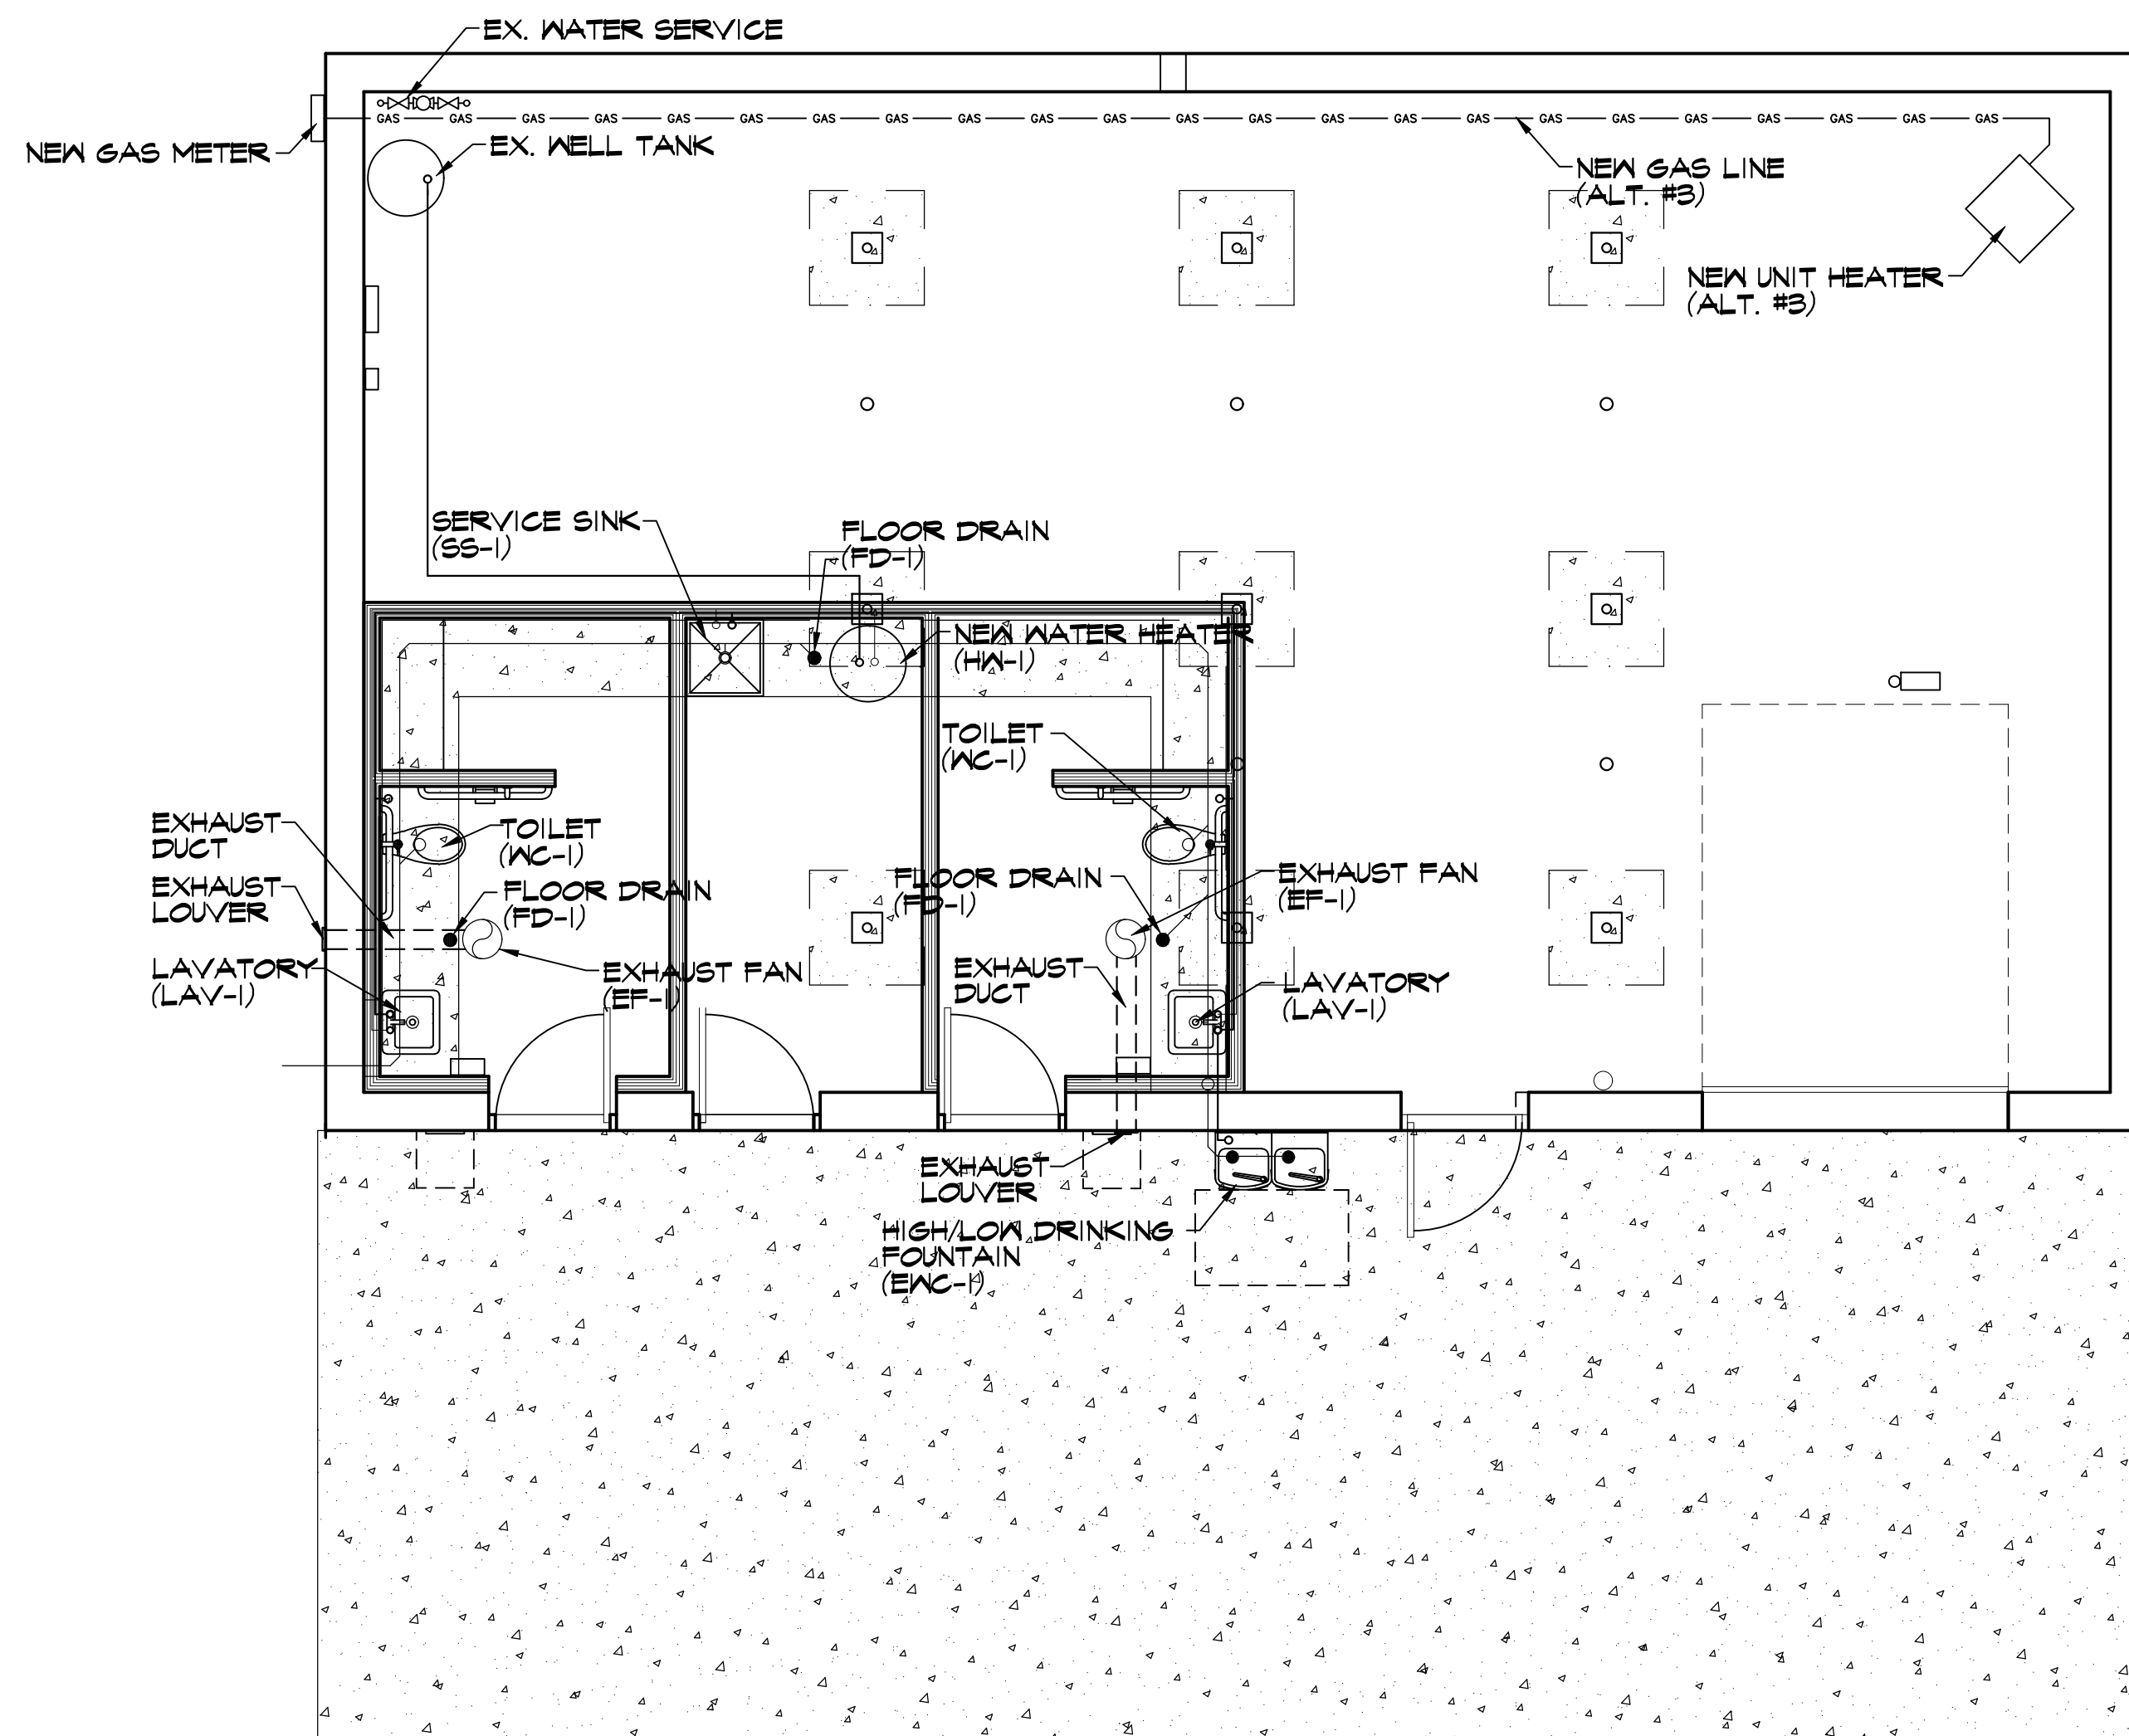
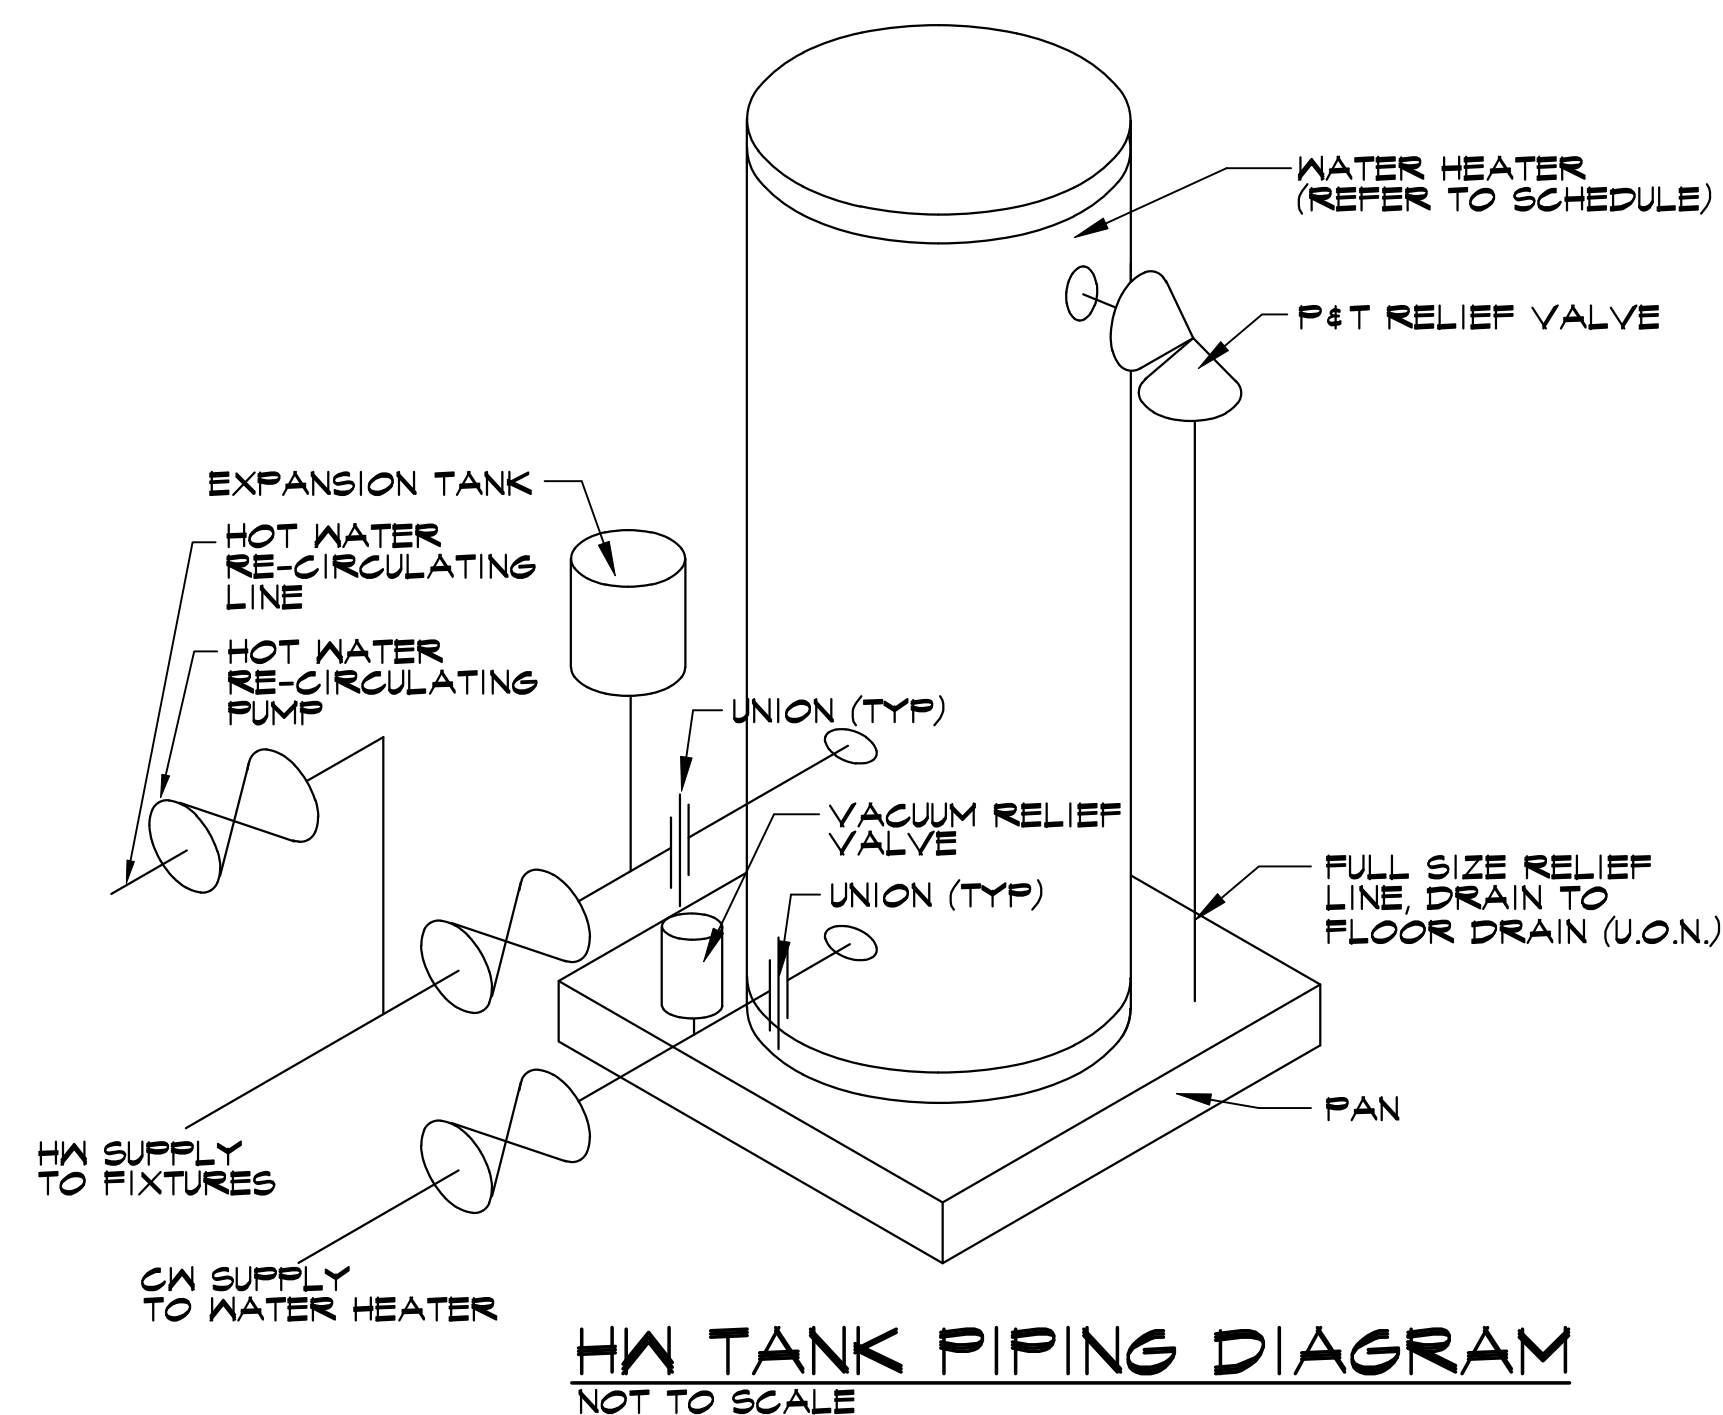
Sheet: **MP-1**

**BASEMENT
MECHANICAL/PLUMBING PLAN**

PLUMBING FIXTURE SCHEDULE

PLUMBING FIXTURE SCHEDULE								
TAG	DESCRIPTION	MFG.	MODEL	ROUGH-IN SIZE			TRIM	REMARKS
				CW	HW	SAN		
WC-1	FLOOR MTD, ELONGATED WATER CLOSET	ELJER	ADA	3/4"	—	4"		CHROME STOP, SUPPLY, OPEN SEAT, FLUSHMETER
LAV-1	WALL MOUNTED VITREOUS CHINA	ELJER	ADA	1/2"	1/2"	1-1/2"	DELTA FAUCET WITH FIXED STRAINER ①	CHROME STOPS, SUPPLIES INSUL SUPPLIES & TRAP
HW-1	ELECTRIC WATER HEATER	RHEEM		1/2"	1/2"	—	3/4" P & T RELIEF VALVE	40 GAL.
SS-1	MOP SERVICE SINK	MUSTEE		3/4"	3/4"	3"	FAUCET W/VACUUM BREAKER	HOSE AND HOSE CARRIER MOP HANGER
EW-C-1	ELECTRIC WATER COOLER	ELKAY		3/4"	—	1-1/2"		HIGH/LOW
FD-1	FLOOR DRAIN	ZURN		3/4"	—	1-1/2"		

① PROVIDE MIXING VALVE TO MEET ADA REQUIREMENTS. 4", MOUNT UNDER LAV.

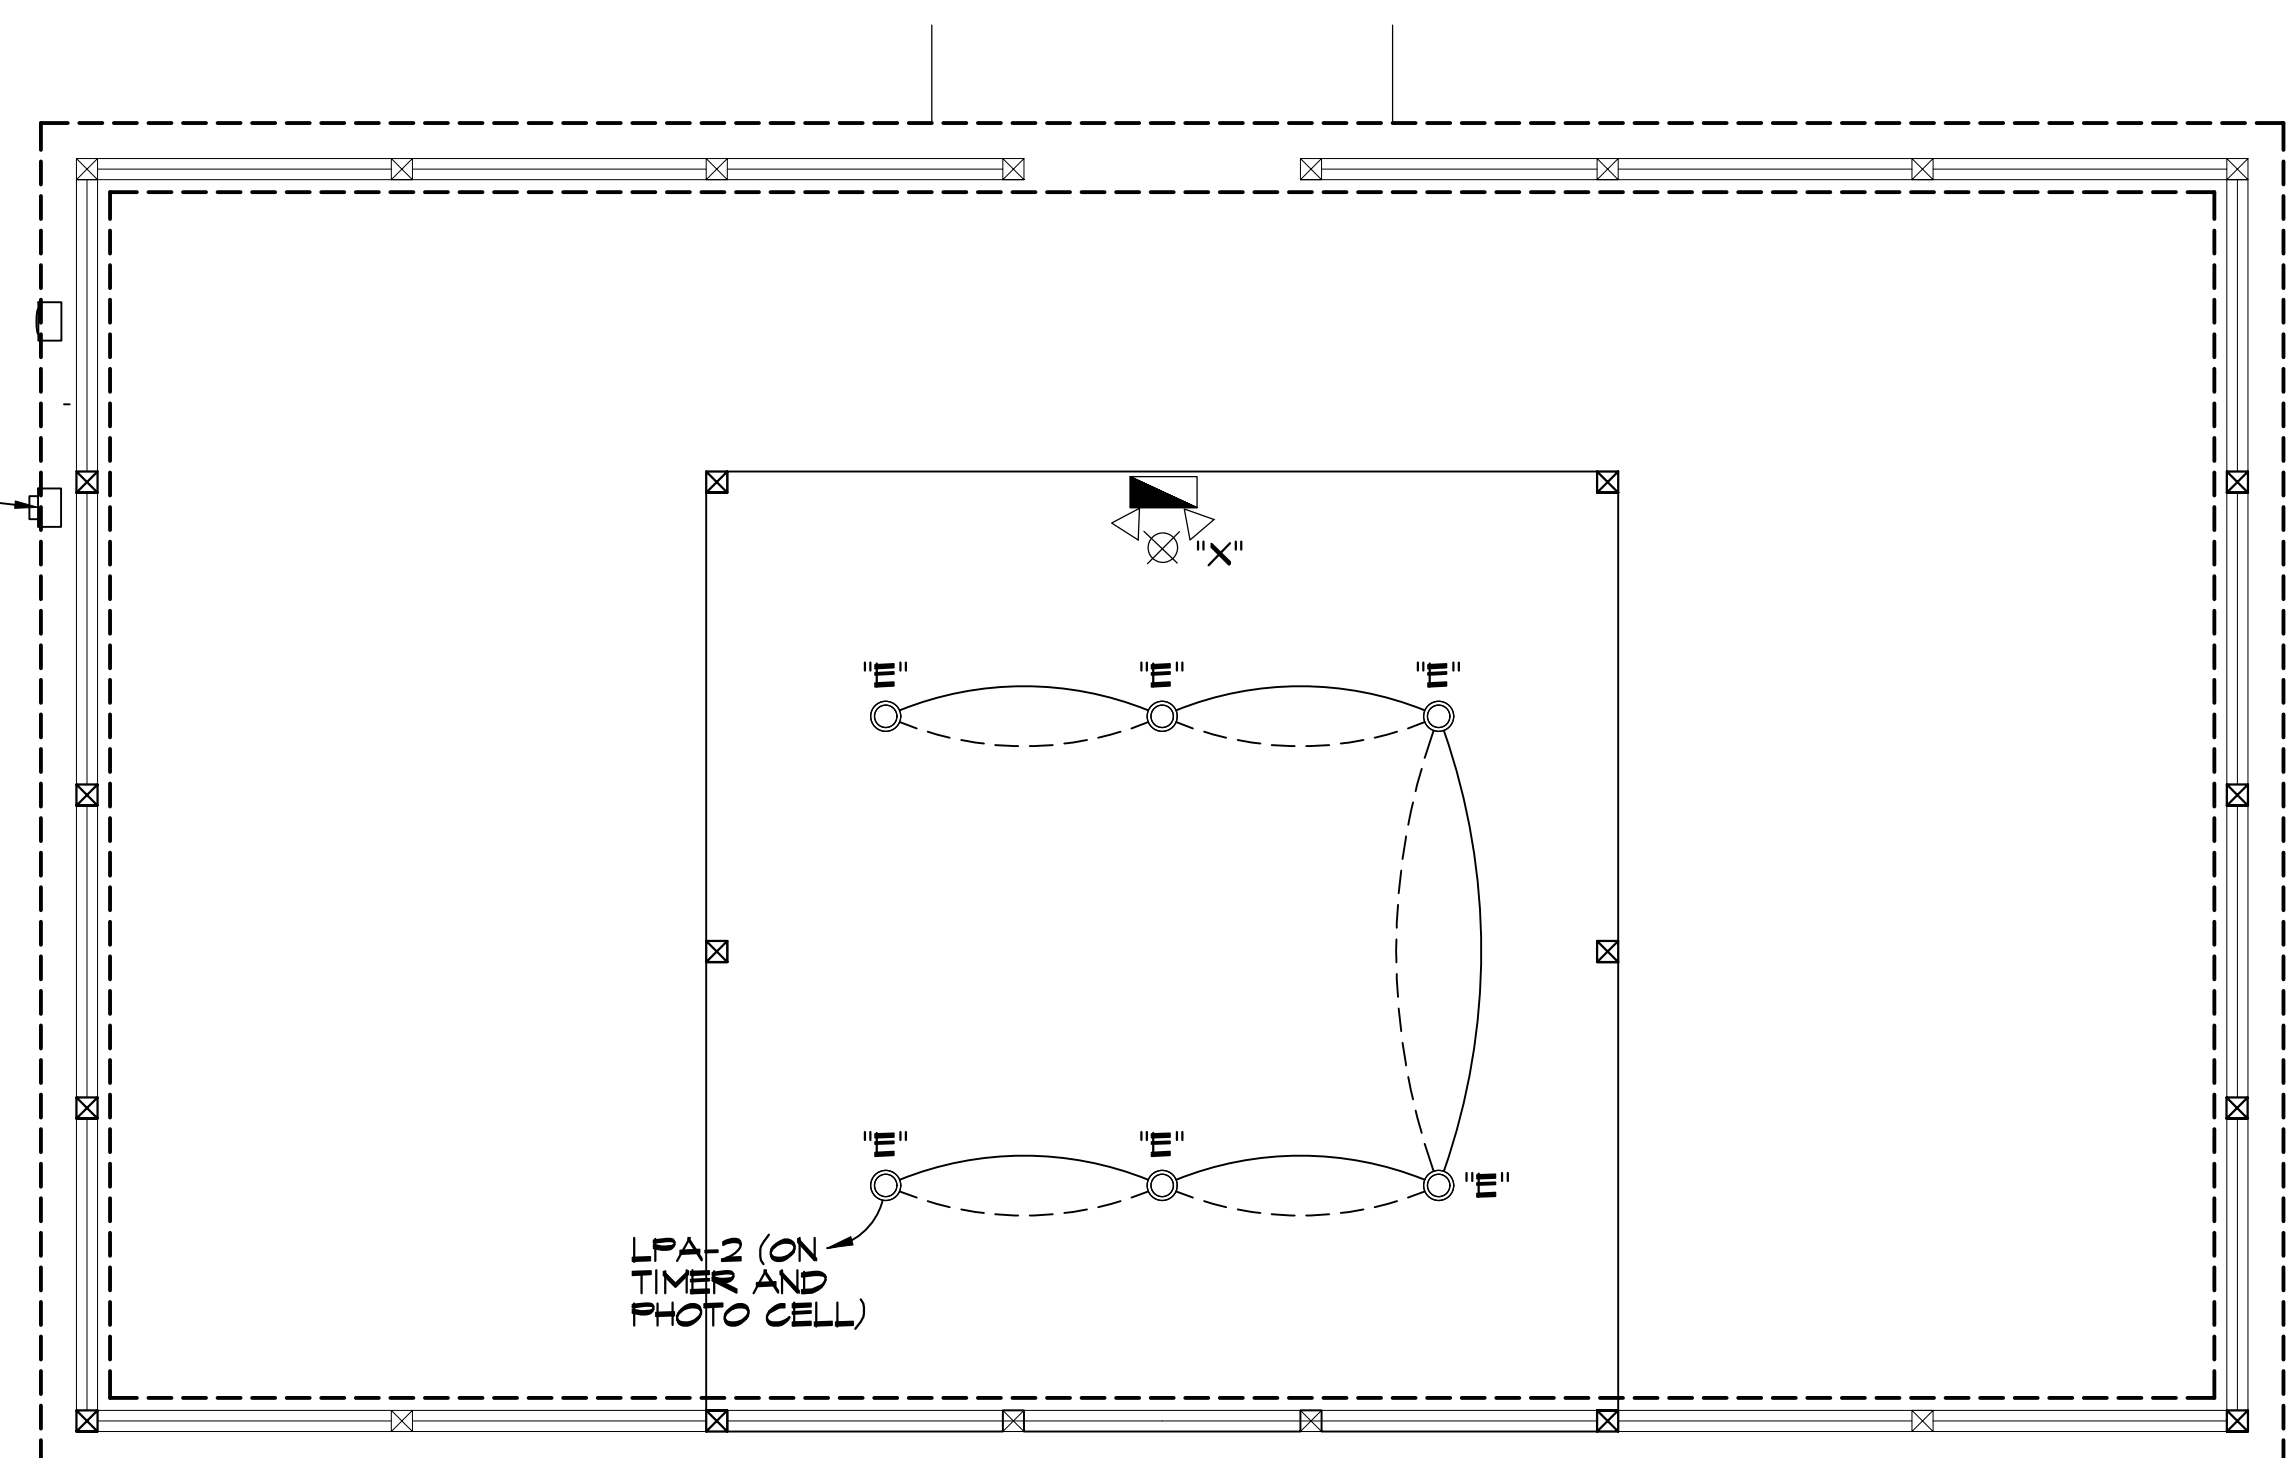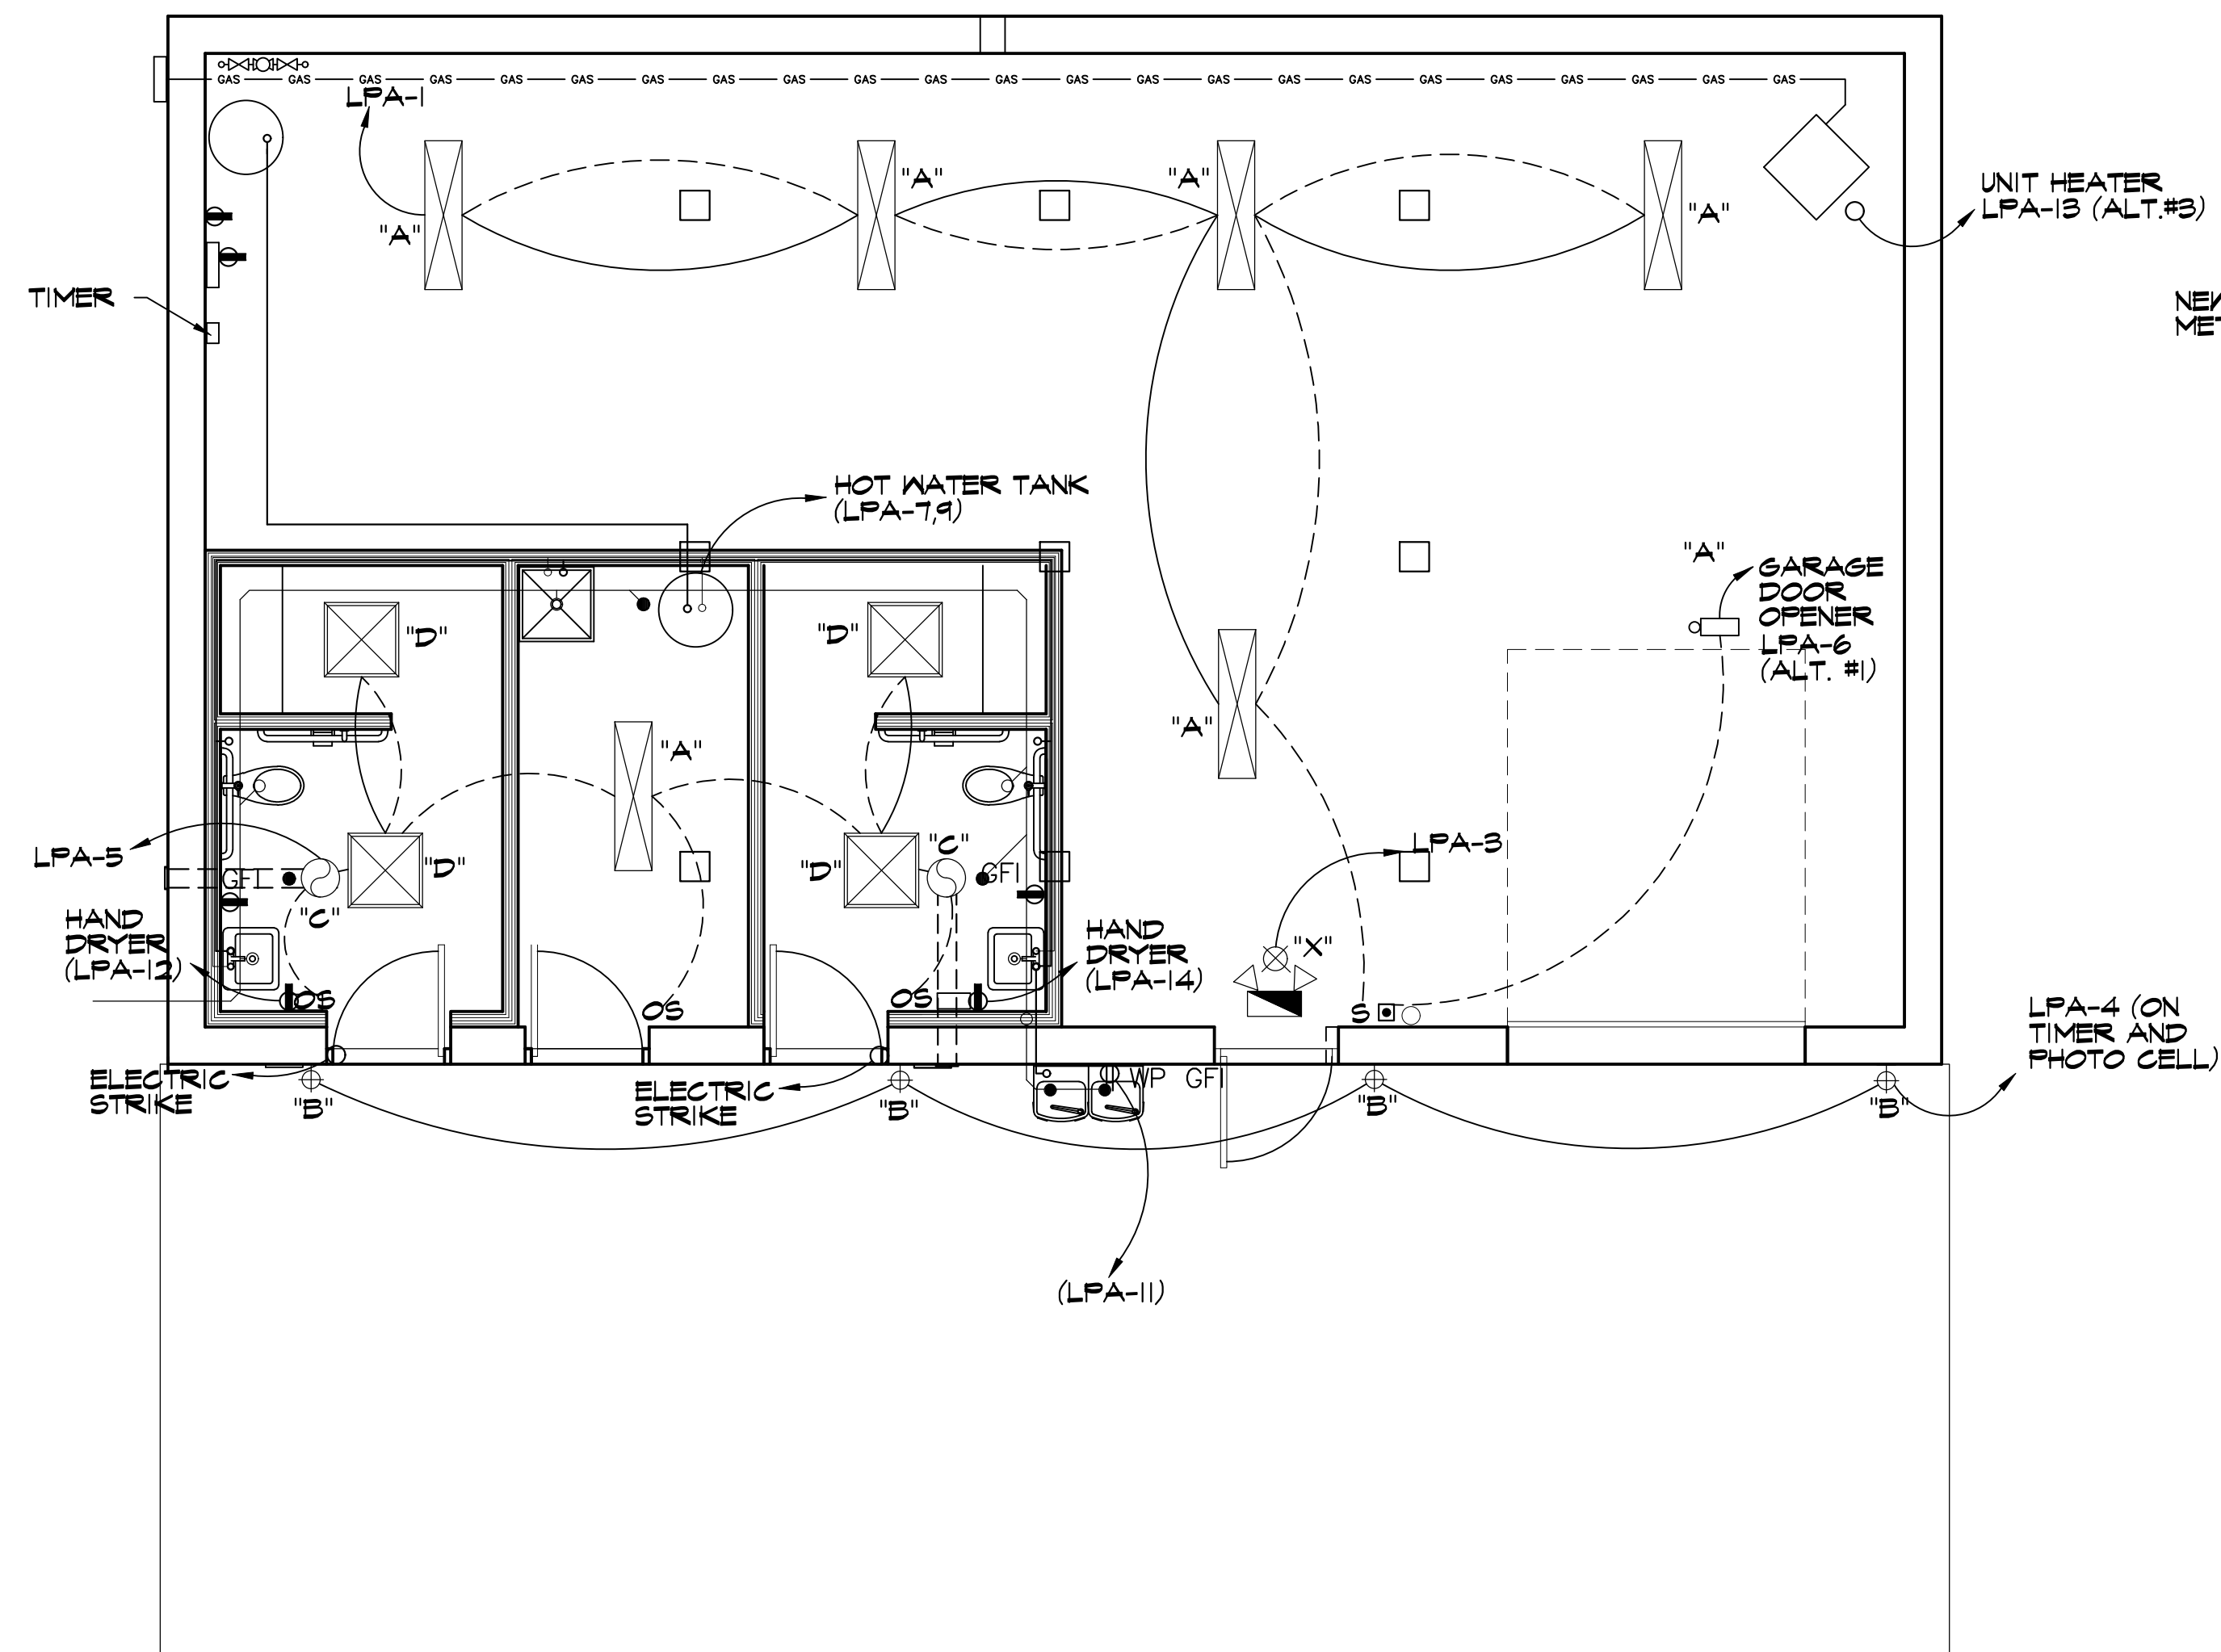

SYMBOL LEGEND	
SYMBOL	DESCRIPTION
S	20A-120V, SINGLE POLE TOGGLE SWITCH MOUNTED 48" AFF UNLESS OTHERWISE NOTED.
R	20A-120V SINGLE POLE REOSTAT SWITCH MOUNTED 48" AFF UNLESS OTHERWISE NOTED.
	15A/125V GROUNDING TYPE DUPLEX CONVENIENCE OUTLET MOUNTED 18" AFF UNLESS OTHERWISE NOTED.
	15A/125V GROUNDING TYPE DUPLEX CONVENIENCE OUTLET MOUNTED 44" AFF UNLESS OTHERWISE NOTED.
	TELEPHONE OUTLET 18" AFF PROVIDE 3/4" C WITH PULLWIRE TO ACCESSIBLE CEILING SPACE.
	JUNCTION BOX SIZE AS REQUIRED.
	LIGHTING PANEL
NL	NIGHT LIGHT
GFI	GROUND FAULT CIRCUIT INTERRUPTER
WP	WEATHERPROOF
	NITE LIGHT
	SMOKE DETECTOR
OS	OCCUPANCY SENSOR

FIXTURE SCHEDULE:

"A" LIGHT FIXTURE TO BE 4' LED LENS FIXTURES, SURFACE MOUNTED, 4000K, 6591 LUMENS/62 WATTS, METALUX 4WSL-LD2-65-SRS-UNV-L840-LDI-SWPD1-U OR APPROVED EQUAL.

"B" LIGHT TO BE EXTERIOR LED WALL PACK-BRONZE FINISH, WALL MOUNTED, 4000K, 1997 LUMENS/18 WATTS, LUMARK XTOR 2B-W OR APPROVED EQUAL.

"C" FAN TO BE PROVIDED AND INSTALLED BY MECHANICAL CONTRACTOR. WIRED BY ELECTRICAL CONTRACTOR

"D" LIGHT FIXTURES TO BE 2X2 LED RECESSED FIXTURES, 400K, 4743 LUMENS/39 WATTS, METALUX 22RTC-48-UNV-L840-CDI-SWPD1-U OR APPROVED EQUAL.

"E" LIGHT FIXTURE TO BE RECESSED LED CAN INSERT, 4000K, 1330 LUMENS/18 WATTS, HALO HT50ICAT-RL56DWH 12940 OR APPROVED EQUAL

"X" EXIT/EMERGENCY LIGHT TO BE LED WITH RED LETTERS, DUAL HEADS, WITH BATTERY BACK UP. FIXTURE TO BE SURELITE APX-TR OR APPROVED EQUAL.

PANELBOARD DESIGNATION: PANEL LP-A						
120/240 VOLTS 3-PHASE 4 WIRE SOLID NEUTRAL						
SURFACE MOUNTED 100 AMP BUS 200 AMP MAIN						
#	KVA	DESCRIPTION		DESCRIPTION	KVA	#
1		LIGHTS		LIGHTS		2
3		EXIT/EMERGENCY		EXTERIOR LIGHT		4
5		LIGHTS/FANS		DOOR OPENER (ALT.#1)		6
7		WATER TANK		WELL TANK		8
9		WATER TANK		WELL TANK		10
11		EWG		HAND DRYER		12
13		UNIT HEATER (ALT.#3)		HAND DRYER		14
15						16
17						18
19						20
21						22
23						24
25						26
27						28
29						30
31						32
33						34
35						36
37						38
39						40
41						42
KVA SUB TOTALS						
CONN'D LOAD KVA						